


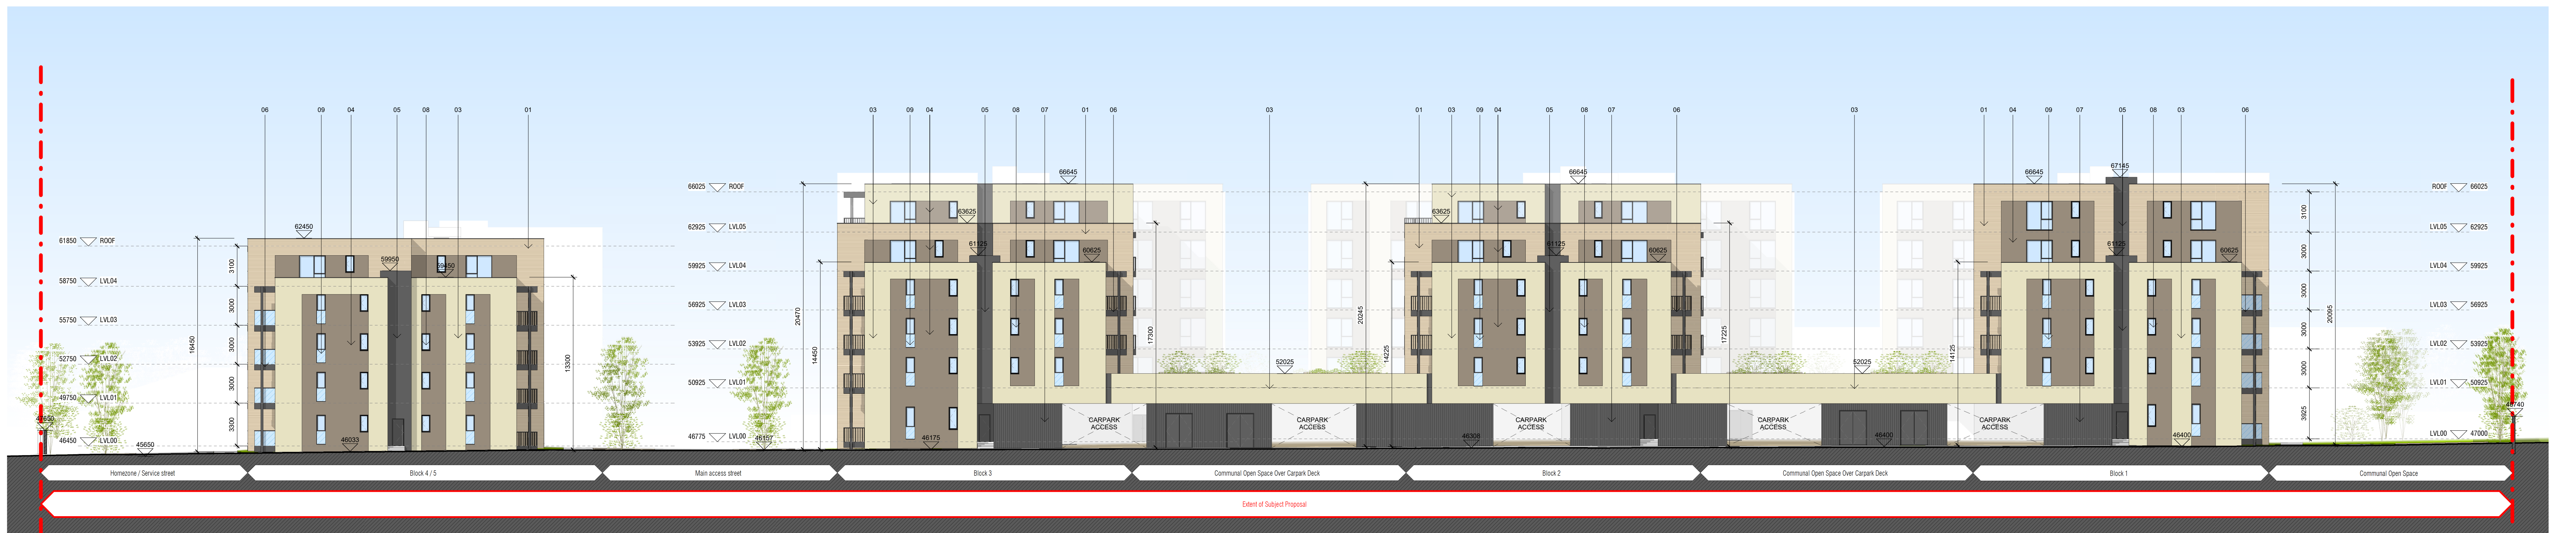

1 Site Elevation - South
1 : 200




2 Site Elevation - North
1 : 200

MATERIAL CODE LEGEND	
01 - BUFF BRICK - STANDARD BOND - LIGHT SAND TONE	
02 - BUFF BRICK - FEATURE BOND - LIGHT SAND TONE	
03 - SELF COLOURED RENDER - CREAM / OFF-WHITE TONE	
04 - SELF COLOURED RENDER - PALE BROWN / TAN TONE	
05 - SELF COLOURED RENDER - DARK GREY / CHARCOAL TONE	
06 - POWDERCOATED METALWORK - DARK GREY / CHARCOAL TONE	
07 - POWDERCOATED METAL SCREENING - DARK GREY / CHARCOAL TONE	
08 - CLEAR GLAZING WITH DARK GREY / CHARCOAL TONE FRAMING	
09 - OPACIFIED GLAZING WITH DARK GREY / CHARCOAL TONE FRAMING TO A HEIGHT OF 1200mm ABOVE FLOOR LEVEL	

- Notes
1. Copyright Reserved
 2. Work to fixed dimensions only. Do not scale drawing.
 3. The contractor is responsible for checking all levels and dimensions on site and shall refer all discrepancies to the Architect.
 4. Where appropriate, for details of r.c. structure, or mechanical and electrical details, see Engineers drawings.
 5. Proprietary items shall be fixed in place in accordance with manufacturers instructions.
 6. Space of proprietary items shall be checked with manufacturer.
 7. The contractor shall be responsible for the coordination of structure, finishes and services.

Issue Status	
Progress	
Planning Application	
Fire Cert	
Disability Cert	
Tender	
Construction	
As-Built	
Information Only	

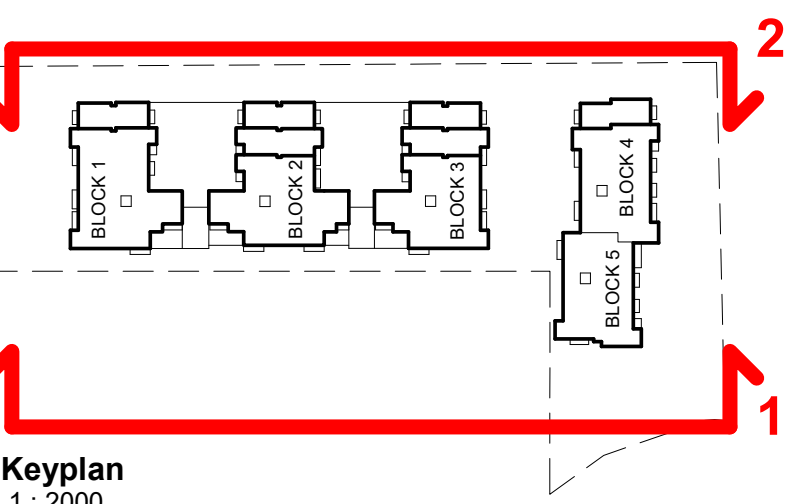

No.	Date	Revised	Revised
1	05/11/22	Issued for T&D Planning	SPD

Project	Carlisle Site Residential Development
Address	50-54 Kimmage Rd West, Kimmage, Dublin 12
Drawing Title	Proposed Site Elevations - North & South
Drawing No	6269 LRD - P - 150
Scale	1:200 @ A0
Rev	1
Drawn	BKD
Date	Oct 2021