



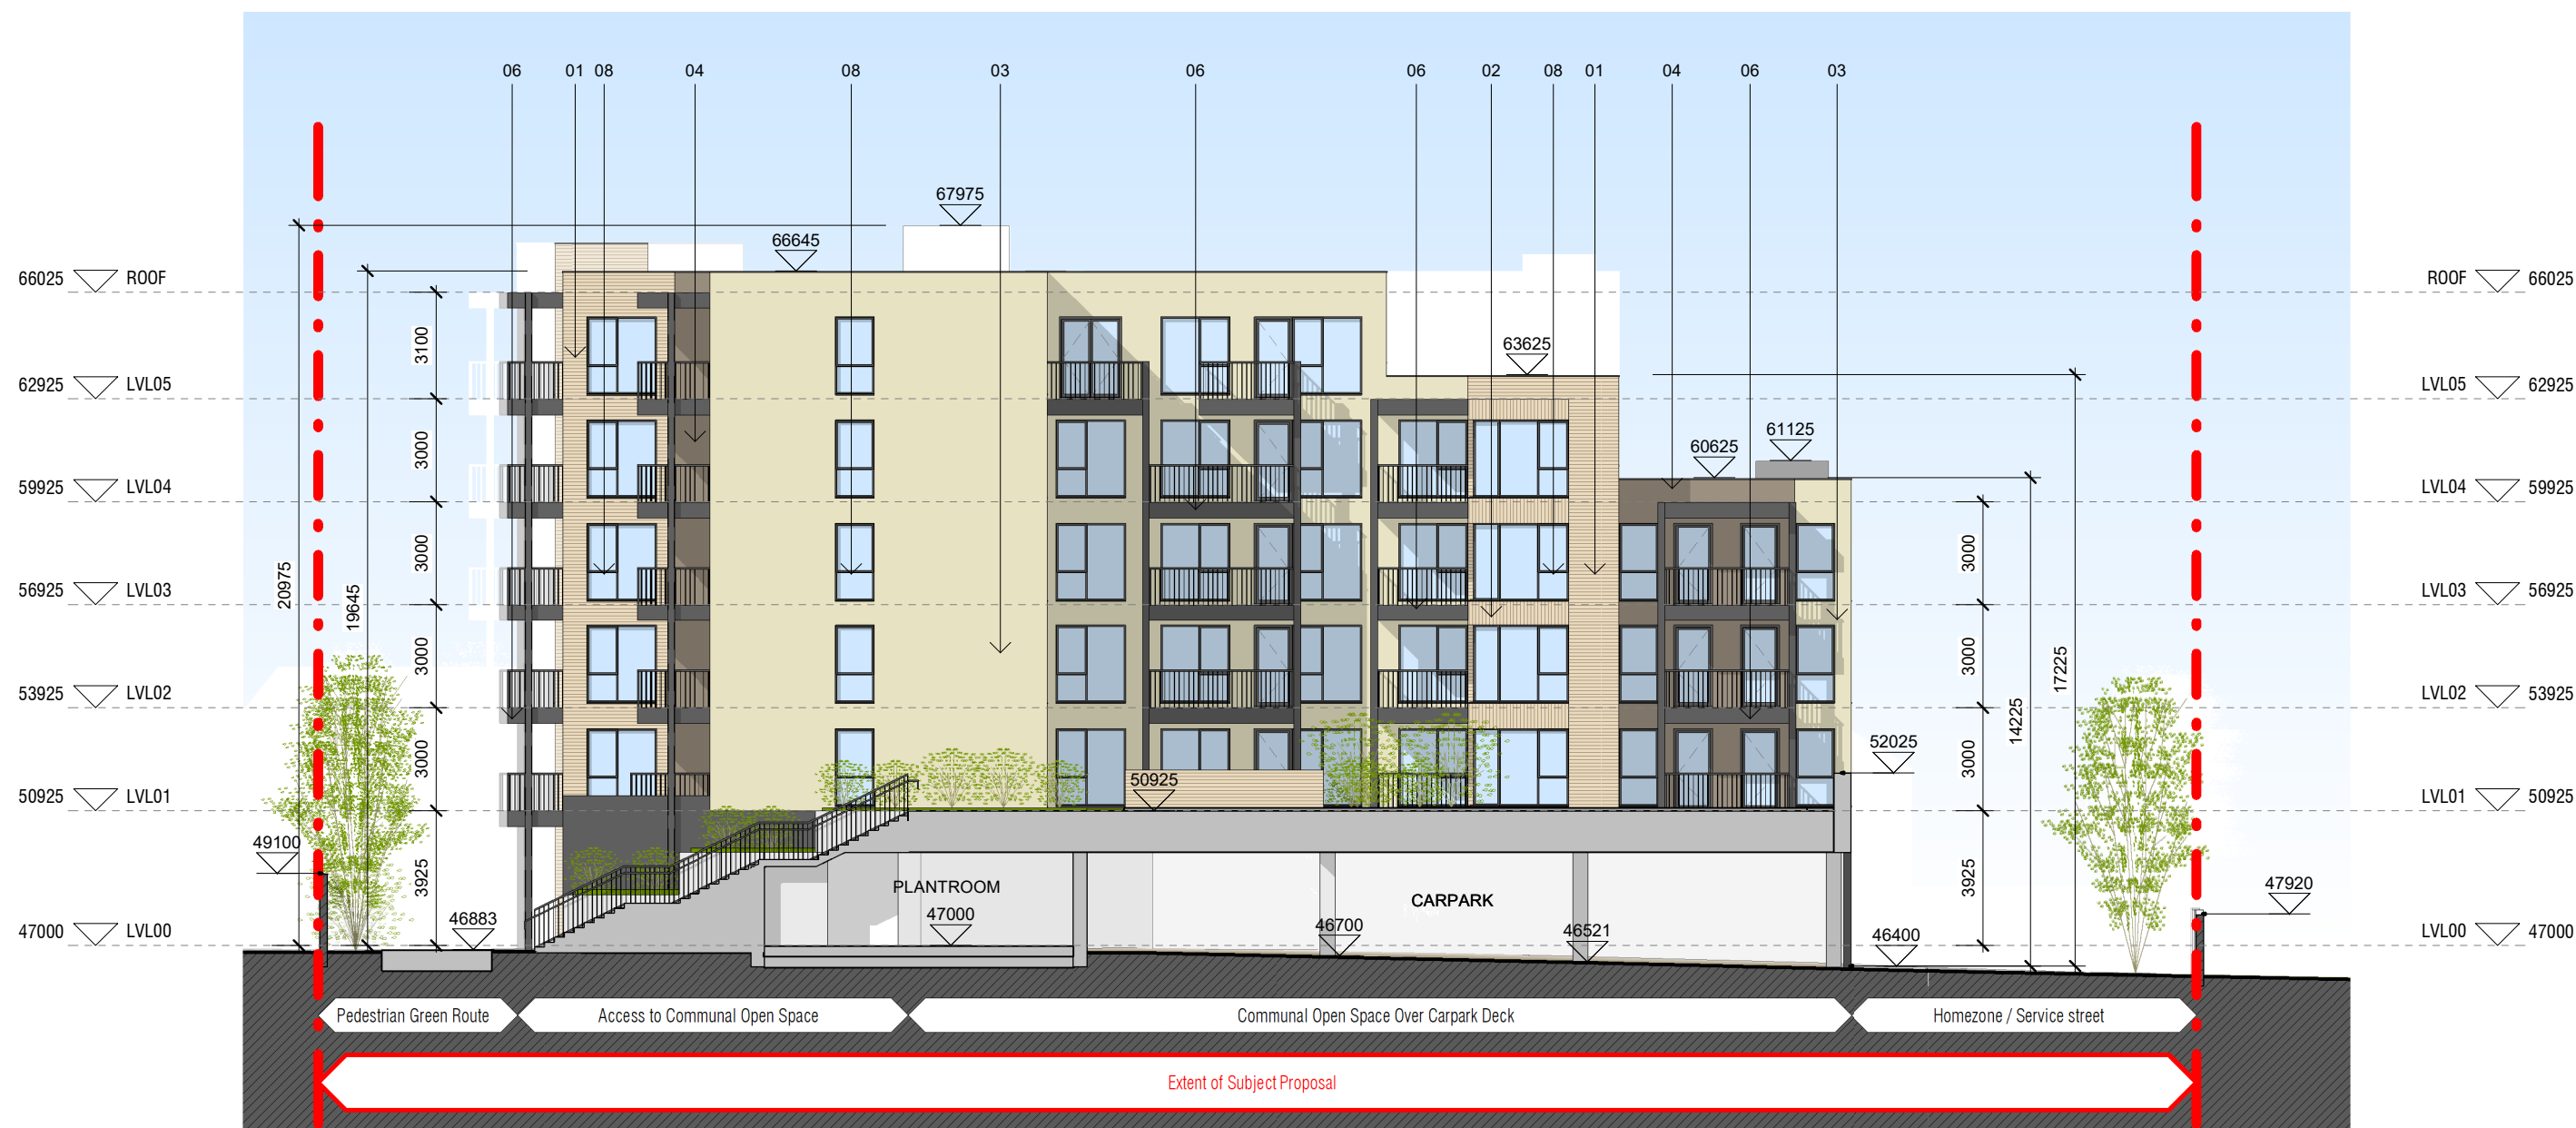


1 Site Elevations - Block2 East Elevation
1 : 200

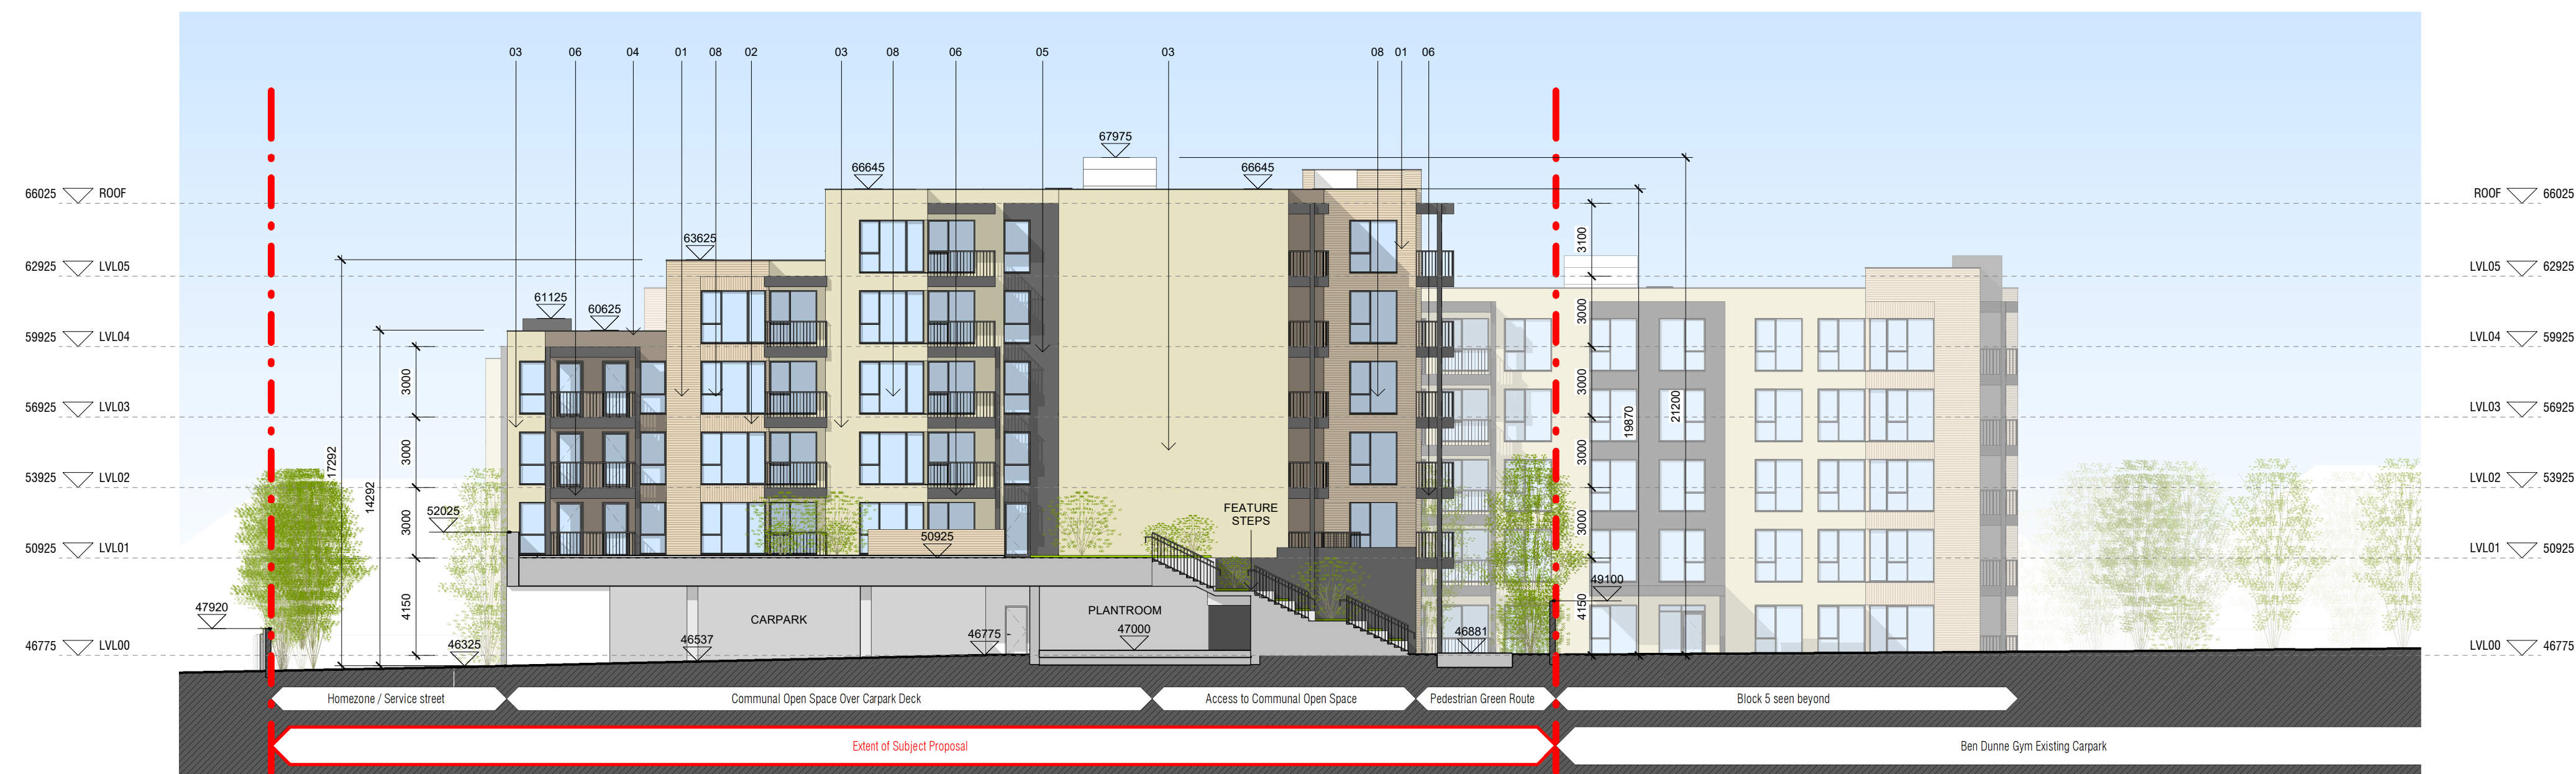

2 Site Elevations - Block3 West Elevation
1 : 200

MATERIAL CODE LEGEND

- 01 - BUFF BRICK - STANDARD BOND - LIGHT SAND TONE
- 02 - BUFF BRICK - FEATURE BOND - LIGHT SAND TONE
- 03 - SELF COLOURED RENDER - CREAM / OFF-WHITE TONE
- 04 - SELF COLOURED RENDER - PALE BROWN / TAN TONE
- 05 - SELF COLOURED RENDER - DARK GREY / CHARCOAL TONE
- 06 - POWDERCOATED METALWORK - DARK GREY / CHARCOAL TONE
- 07 - POWDERCOATED METAL SCREENING - DARK GREY / CHARCOAL TONE
- 08 - CLEAR GLAZING WITH DARK GREY / CHARCOAL TONE FRAMING
- 09 - OPACIFIED GLAZING WITH DARK GREY / CHARCOAL TONE FRAMING TO A HEIGHT OF 1200mm ABOVE FLOOR LEVEL

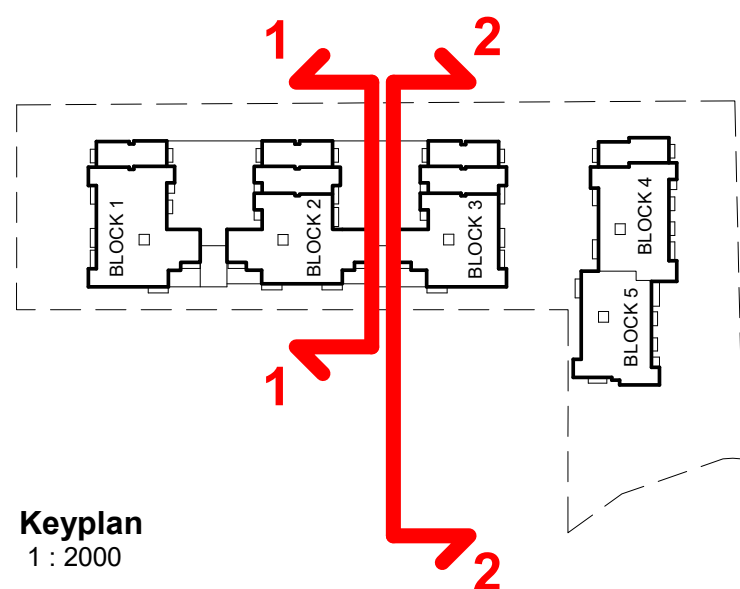

Keyplan
1 : 2000

Notes		Issue Status			
1. Copyright Reserved		Progress			
2. Work to figured dimensions only. Do not scale drawing.		Planning Application			
3. The contractor is responsible for checking all levels and dimensions on site and shall refer all discrepancies to the Architect		Fire Cert			
4. Where appropriate, for details of r.c. structure, or mechanical and electrical details, see Engineers drawings		Disability Cert			
5. Proprietary items shall be fixed in strict accordance with manufacturers instructions.		Tender			
6. Sizes of proprietary items shall be checked with manufacturer.		Construction			
7. The contractor shall be responsible for the coordination of structure, finishes and services.		As Built			
		Information Only			

No.	Date	Revision	Issued
1	02/11/23	Issued for LRD Planning	BKD

Project		Carlisle Site Residential Development	
		52-54 Kimmage Rd West, Kimmage, Dublin 12	
Drawing Title		Proposed Site Elevations - Internal Elevations - Sheet 2/3	
Drawing No		6269 LRD - P - 153	
Scale	1:200@A1	Rev	1
Drawn	BKD	Date	Oct 2021

6-7 HARCOURT TERRACE, DUBLIN 2, IRELAND
t +353-1-618 2400 f +353-1-678 7385
www.bkd.ie

bkdarchitects
B U R K E - K E H R E D Y D O Y L E