




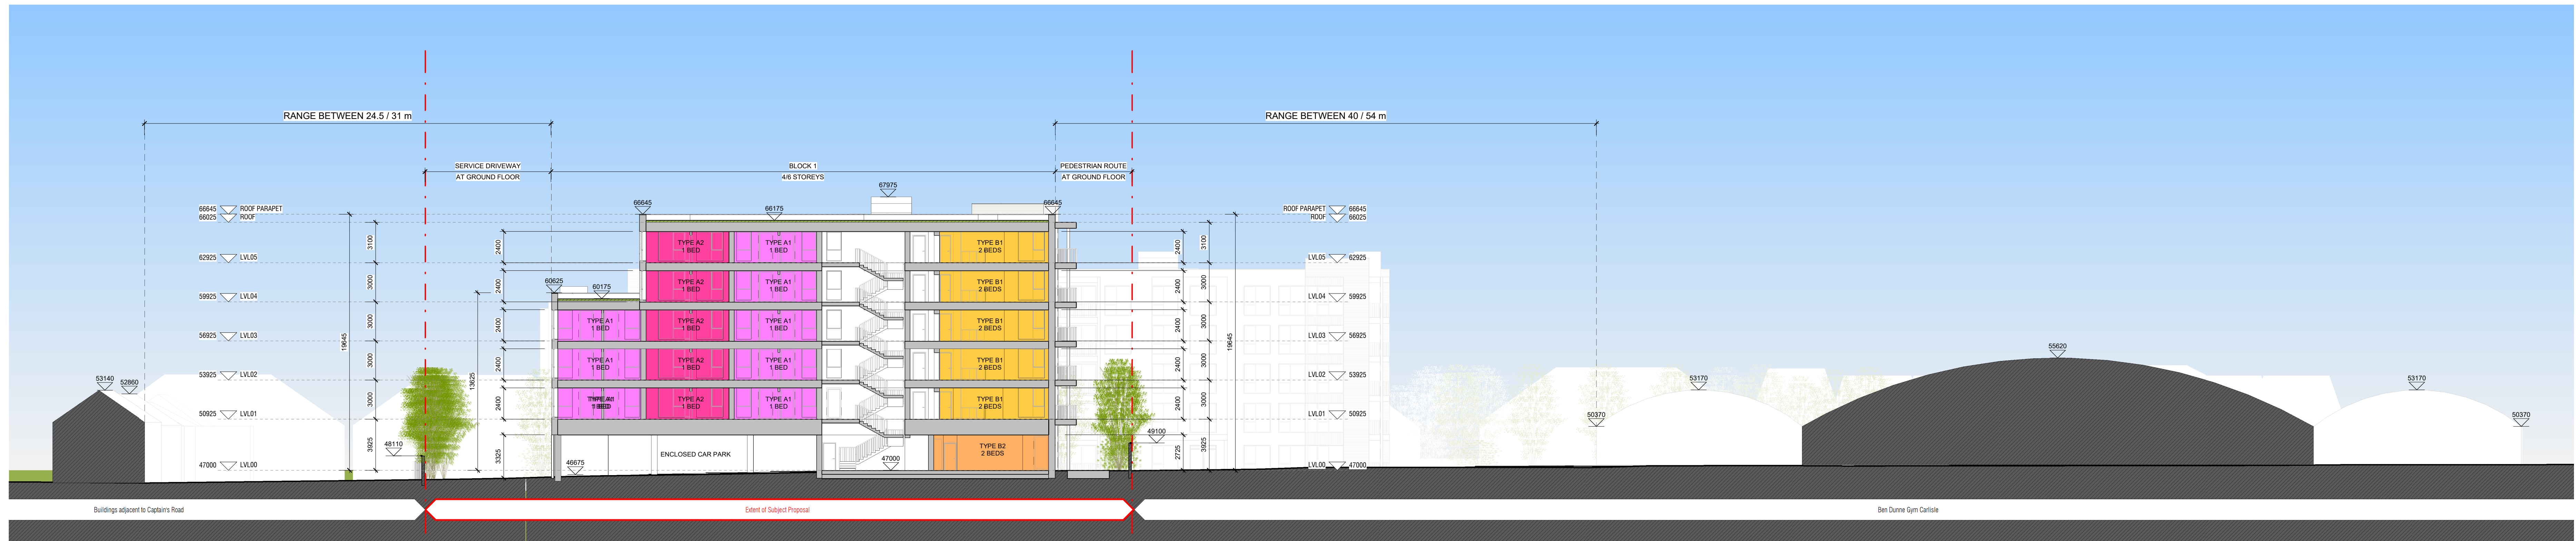


A Site Sections - Section A-A
1:200

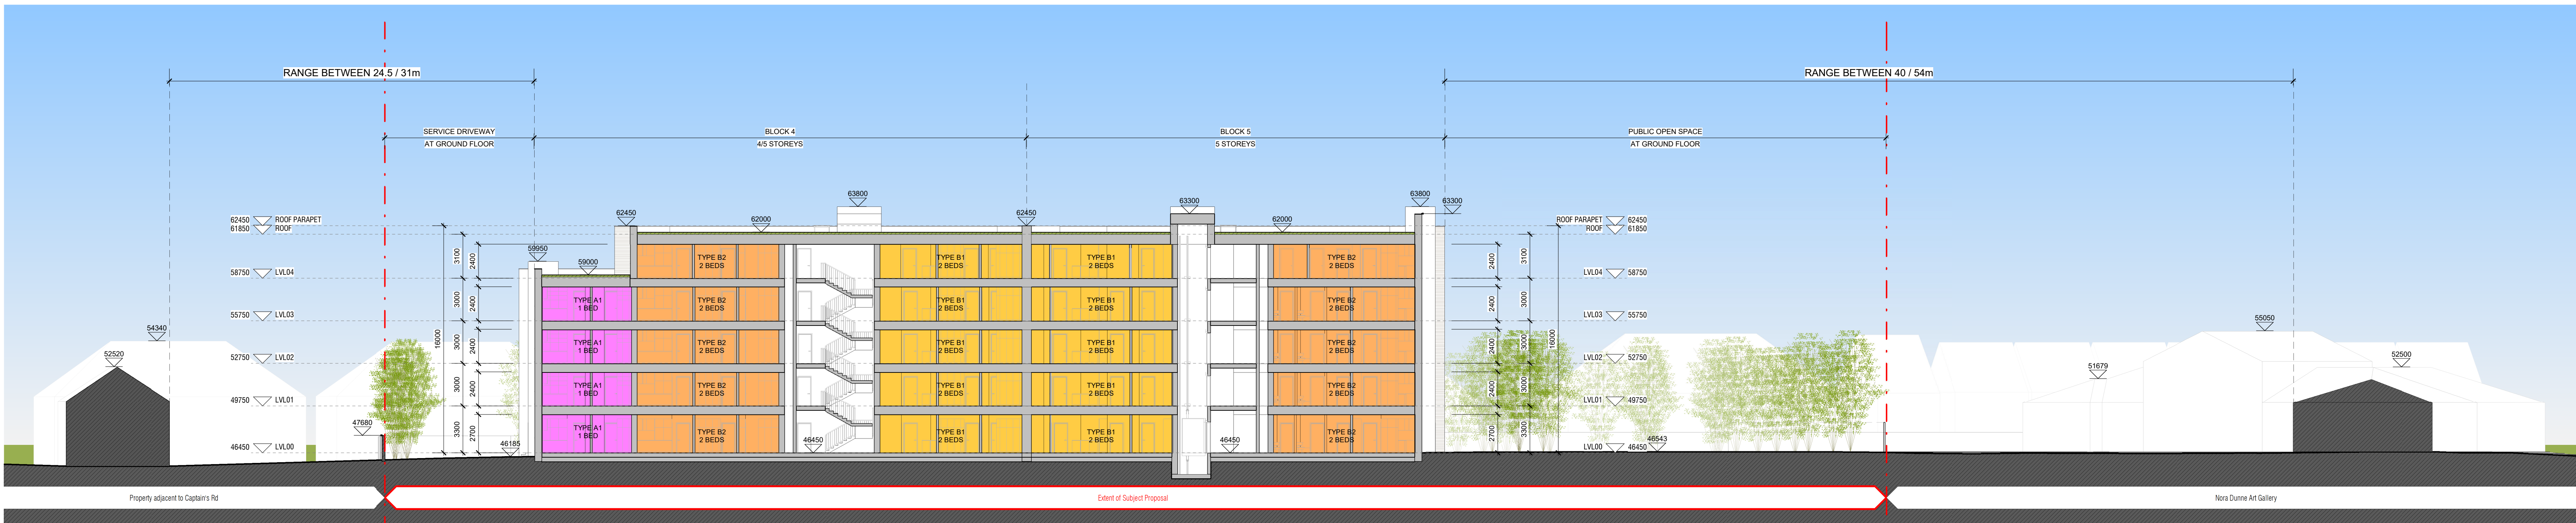

B Site Sections - Section B-B
1:200

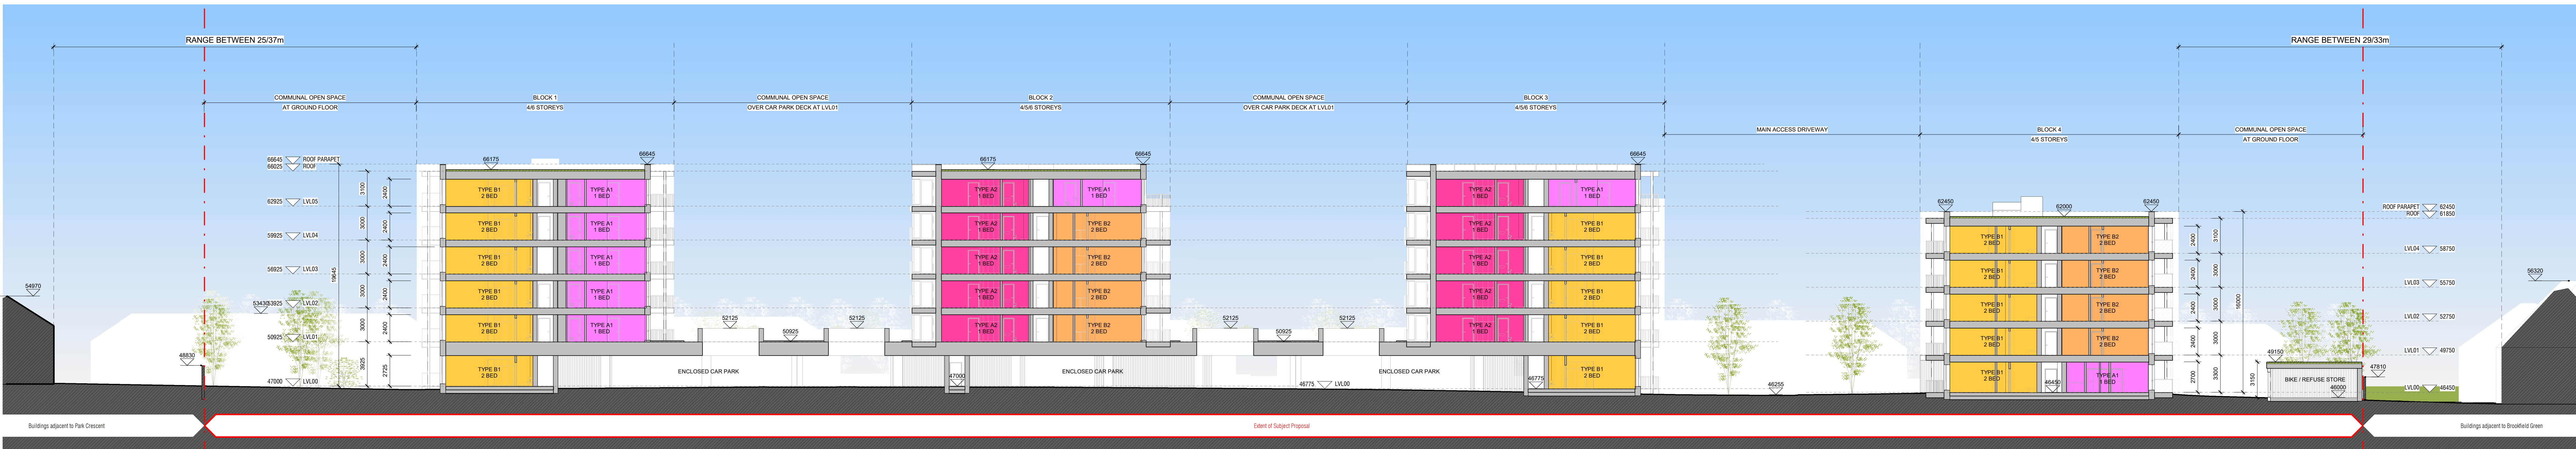

C Site Sections - Section C-C
1:200

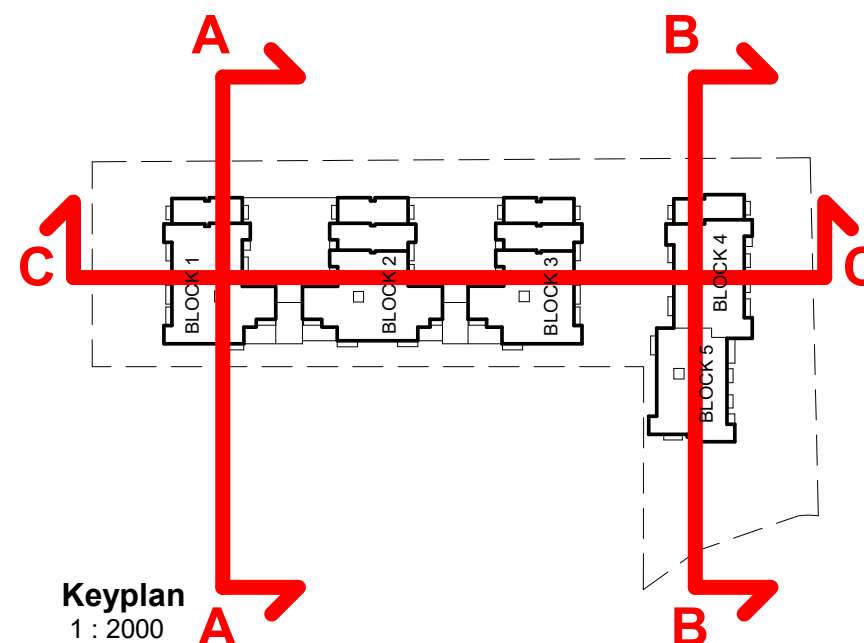

Notes:
1. Copyright Reserved
2. Work to signed dimensions only. Do not scale drawings.
3. The contractor is responsible for checking all levels and dimensions on site and shall refer all discrepancies to the Architect.
4. Where appropriate, for details of r.c. structure, or mechanical and electrical details, see Engineers drawings.
5. Preliminary items shall be fixed in strict accordance with manufacturers instructions.
6. State of proprietary items shall be checked with manufacturer.
7. The contractor shall be responsible for the coordination of structure, finishes and services.

Issue Status
Progress
Planning Application
Fire Cert.
Disability Cert
Tender
Construction
As Built
Information Only

No.	Date	Issued for LRD Planning	Revision	Issued
1	10/11/22	Issued for LRD Planning		SPD

Project: Carlisle Site Residential Development
62-64 Kimmage Rd West, Kimmage, Dublin 12
Drawing Title: Proposed Sections
Drawing No: 6269 LRD - P - 160
Scale: 1:200 @ A0
Rev: 1
Drawn: VF
Date: Oct 2021

6-7 PHANCOURT TERRACE, DUBLIN 2, IRELAND
+353 1 616 3600 / +353 1 478 7380
www.bkd.ie
bkd architects
BRIAN KERRYBOY DOYLE