
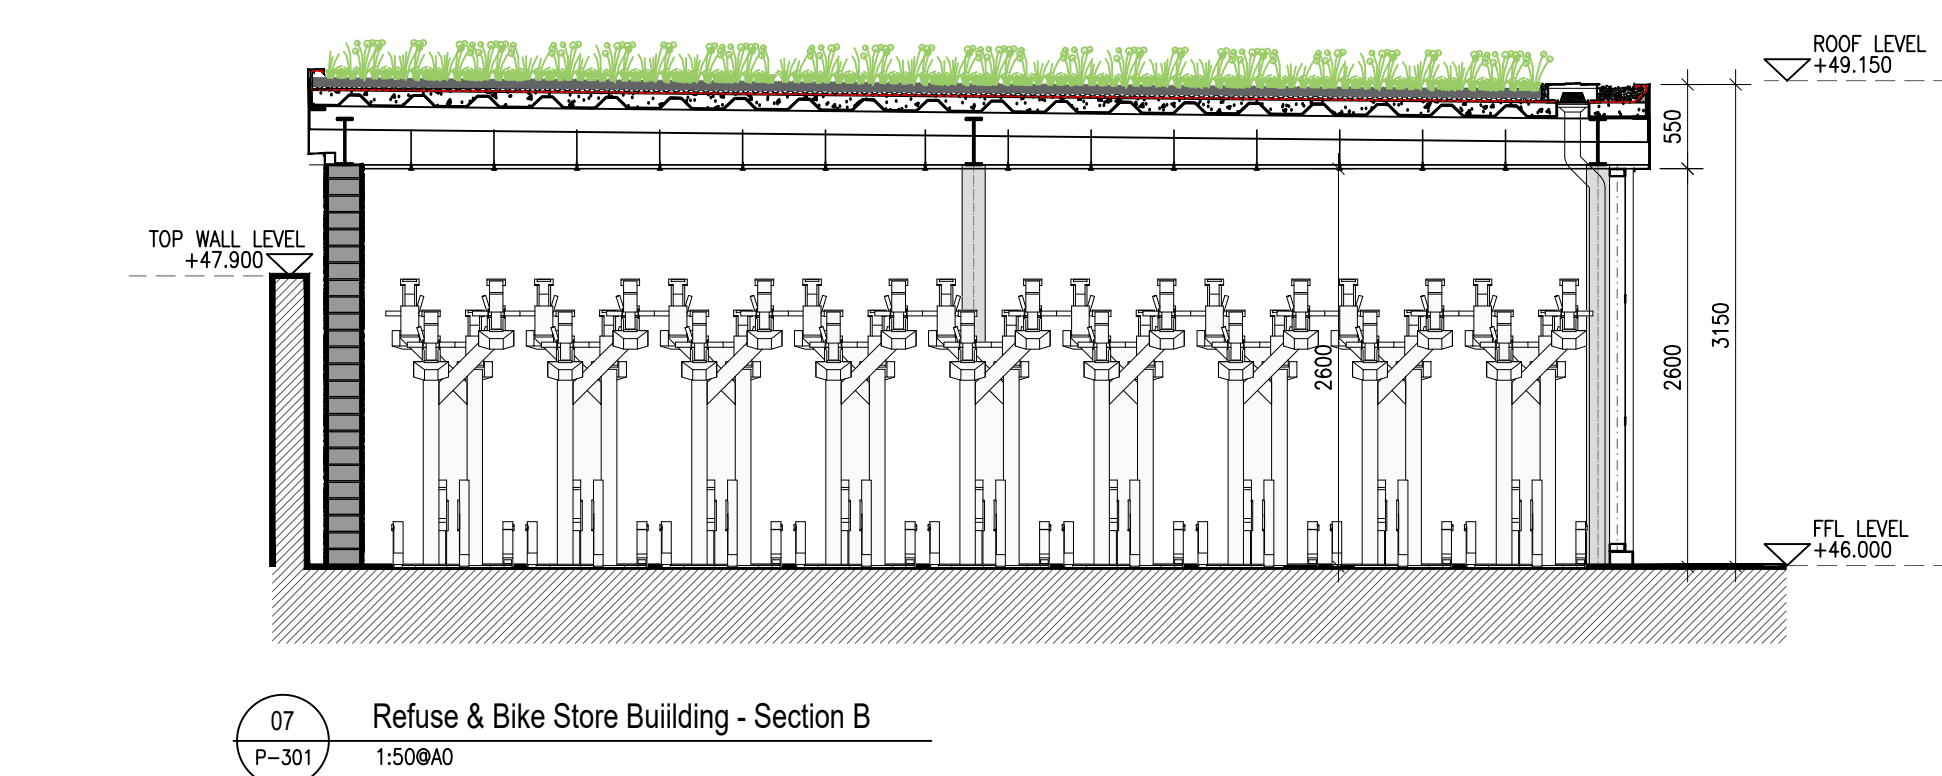
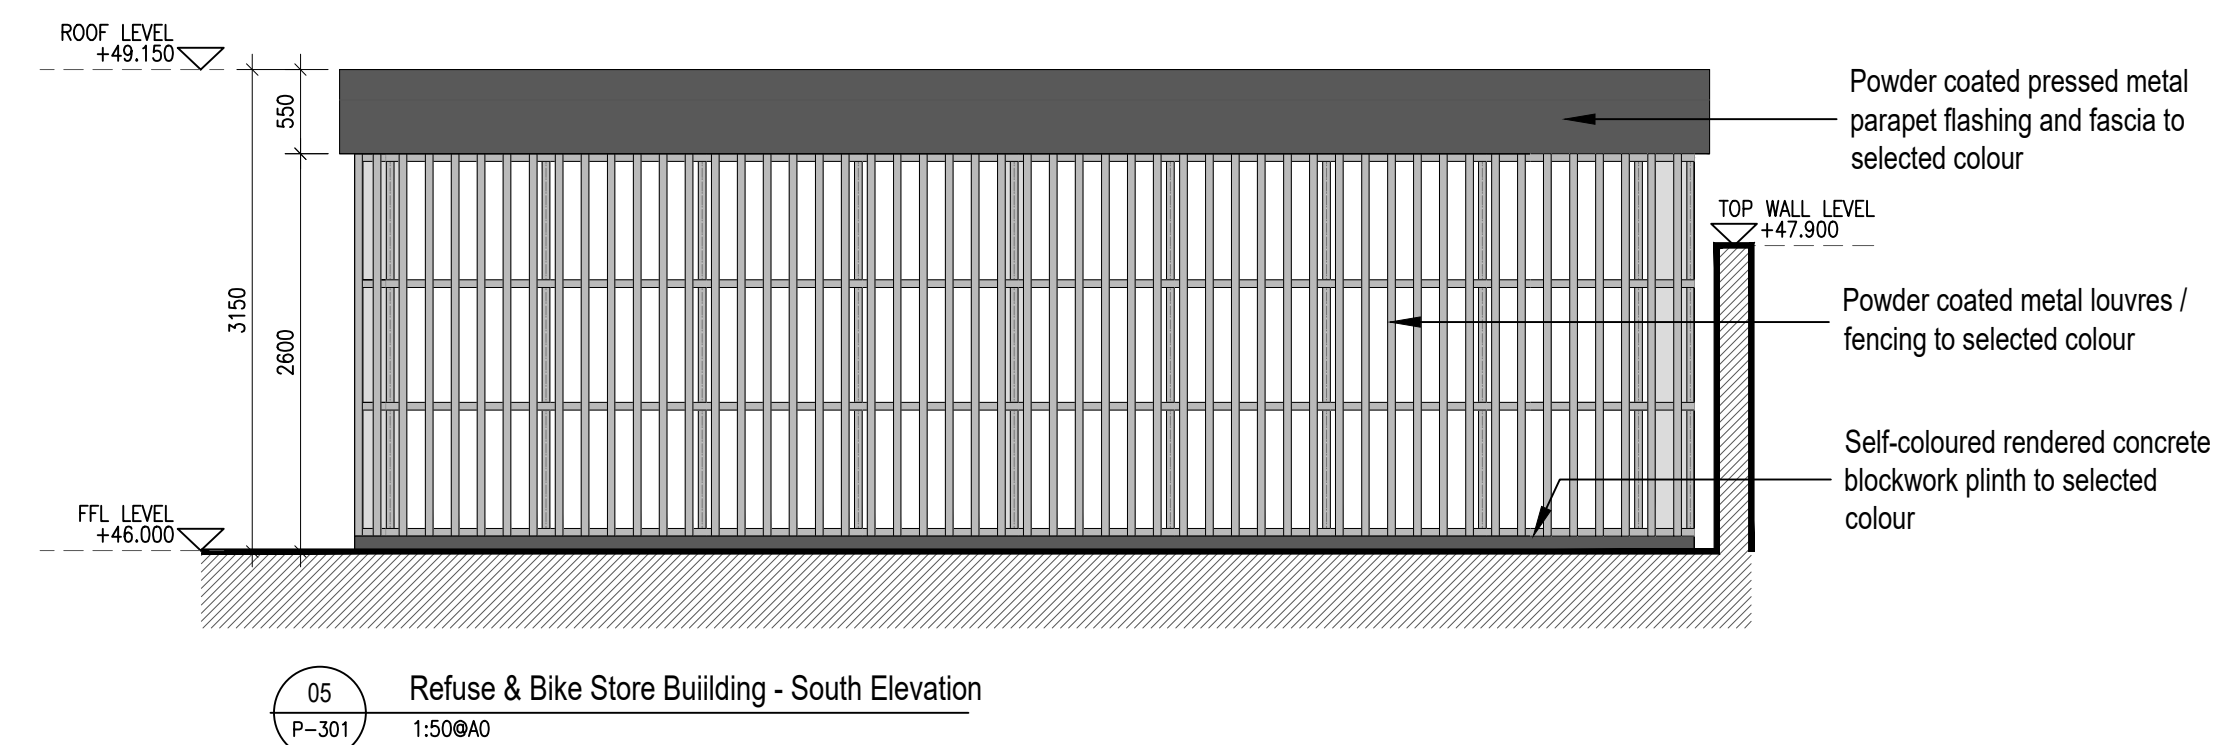
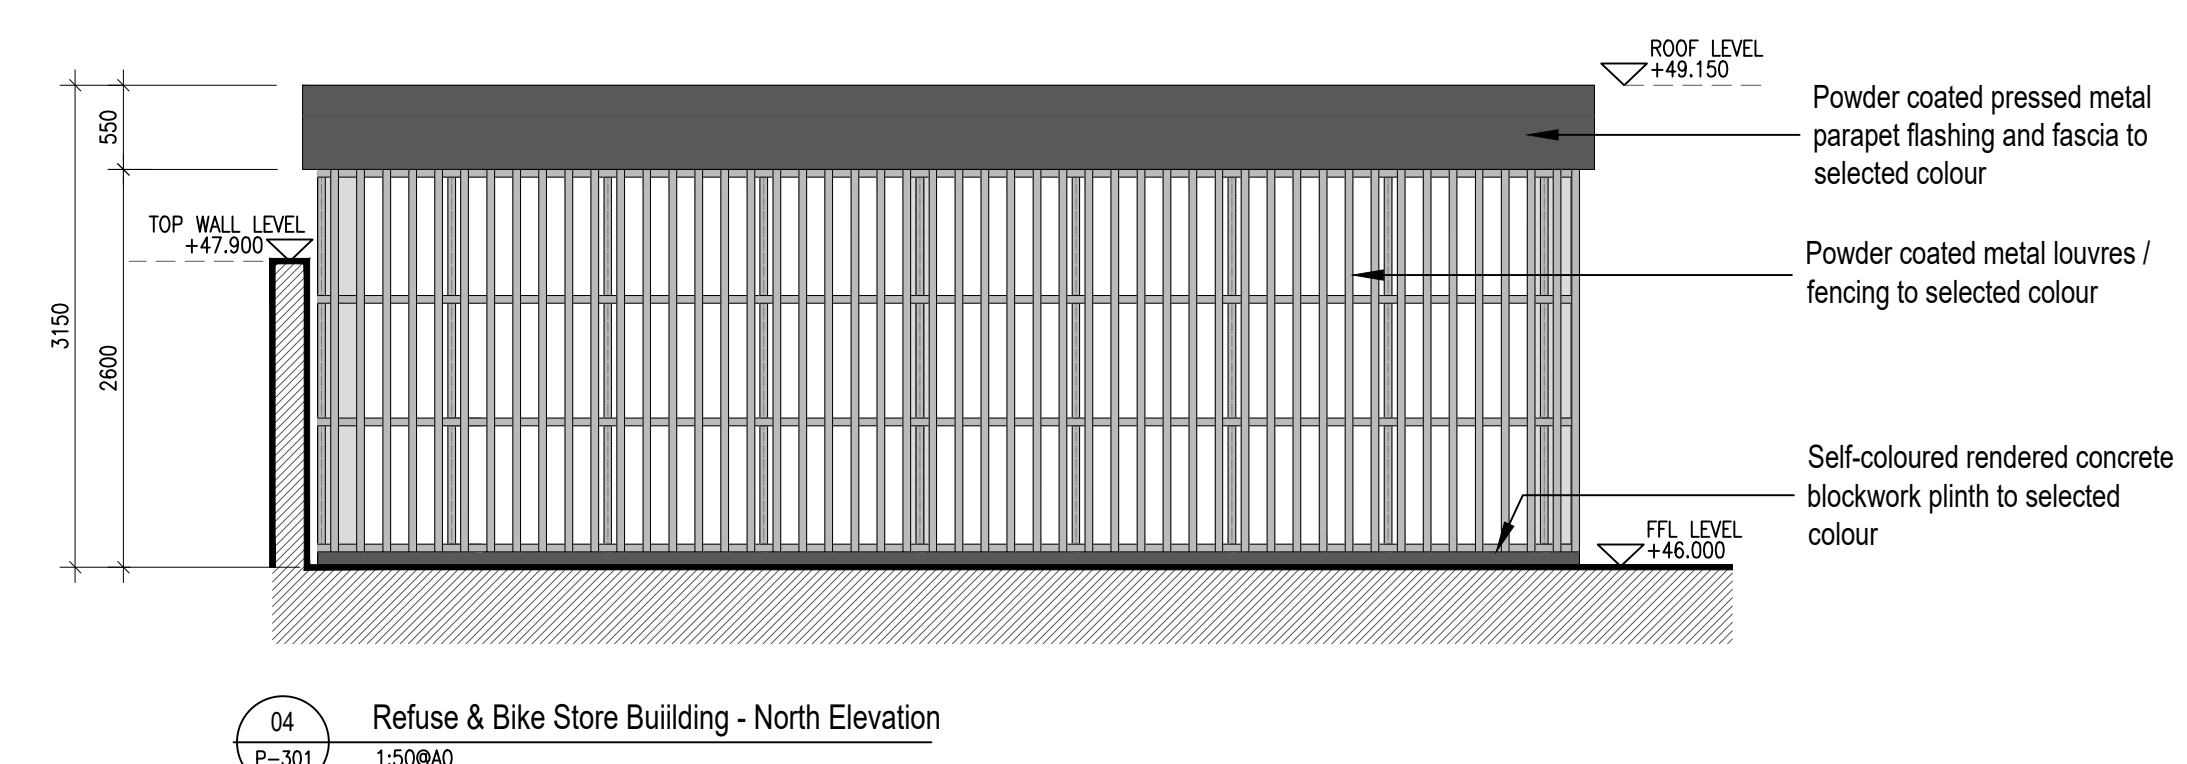


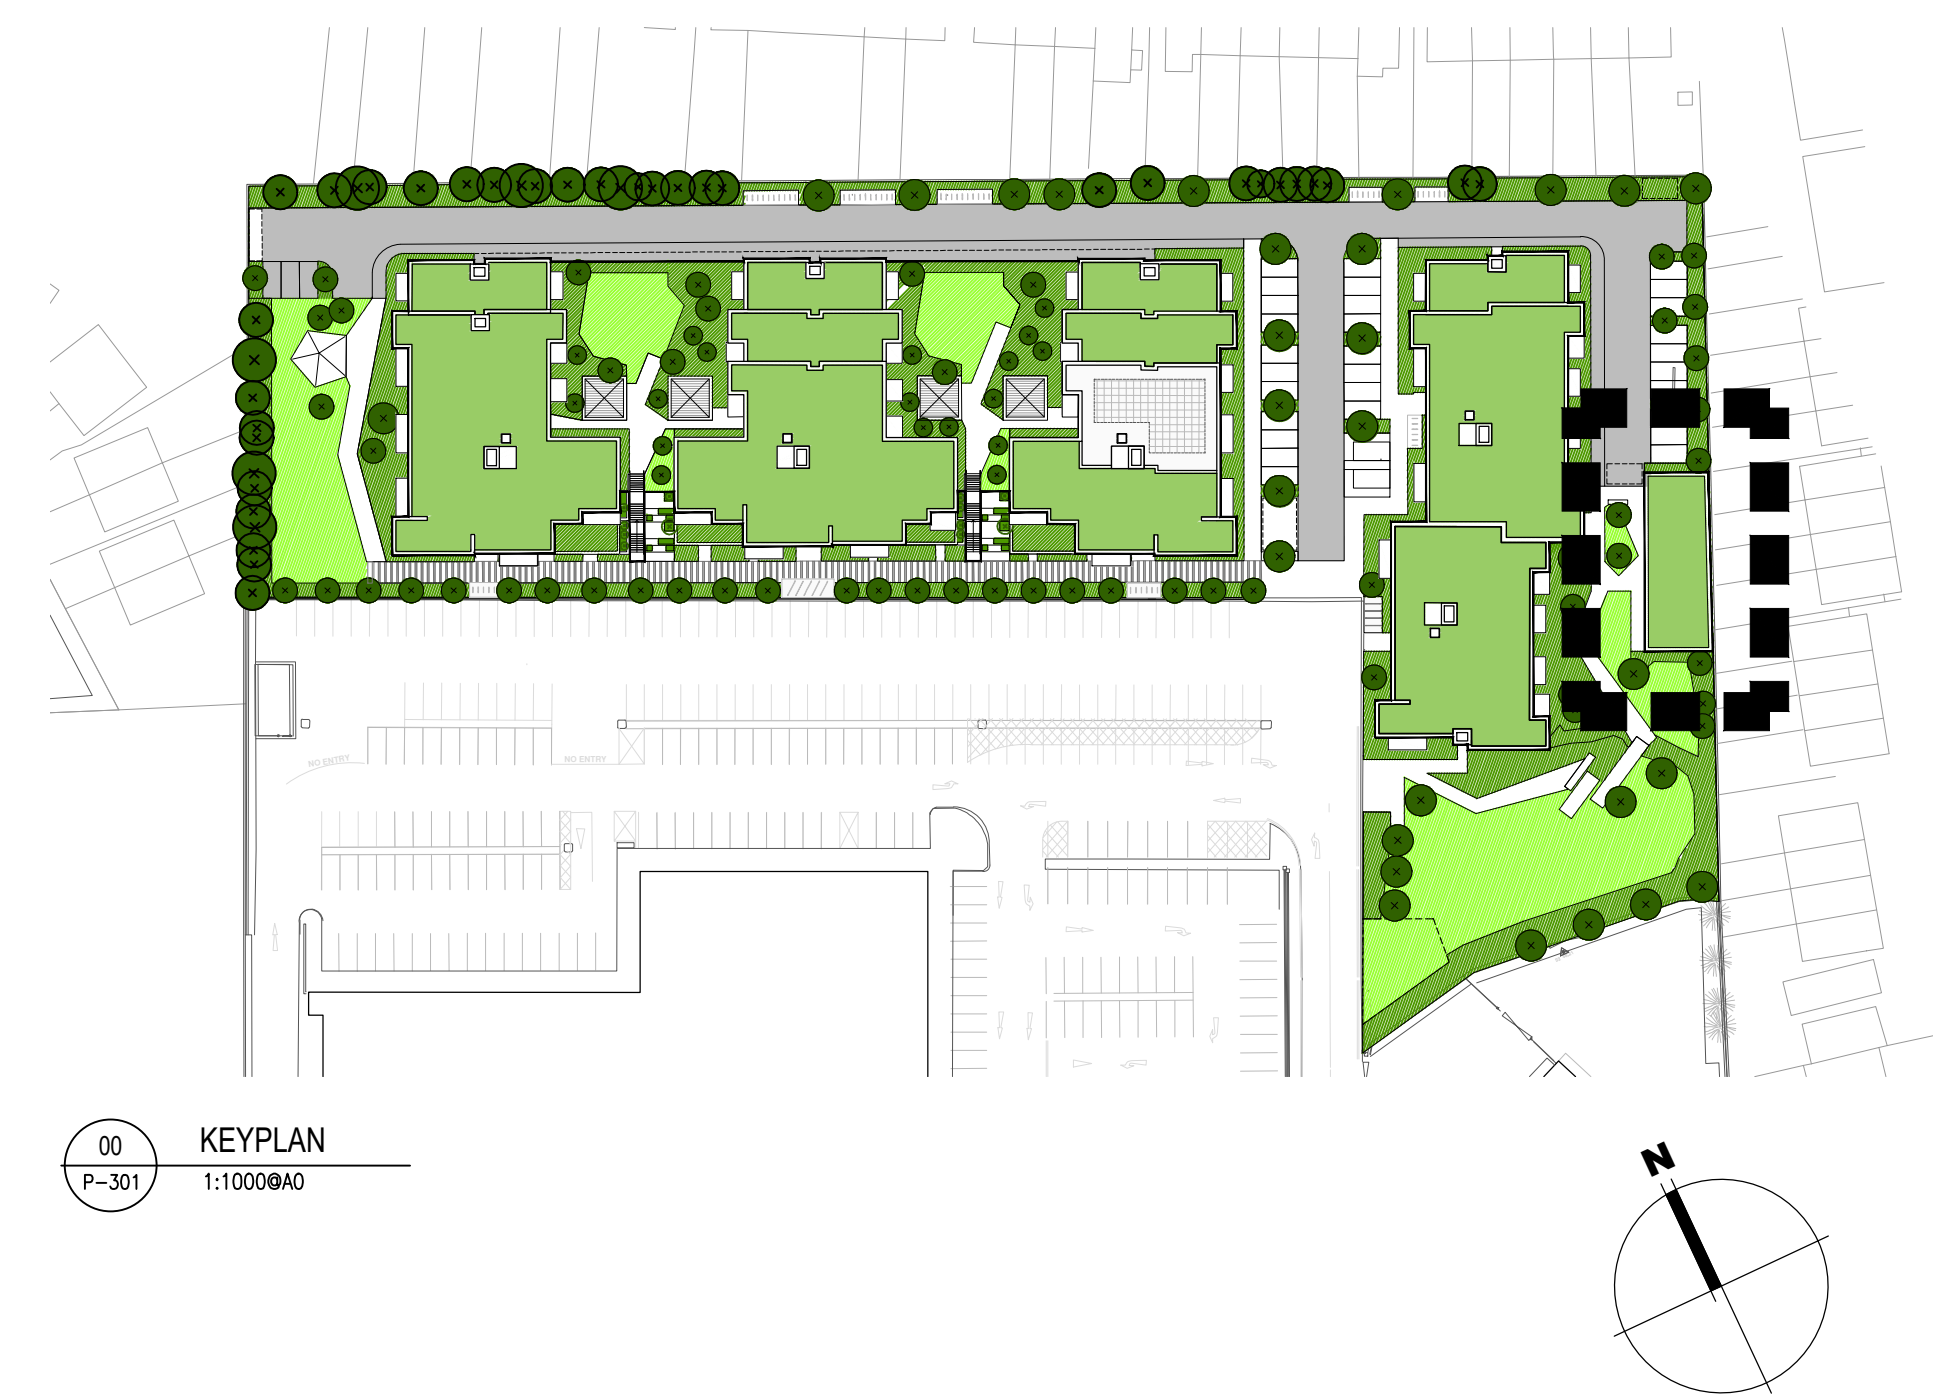

Notes		Issue Status		Revision		Initials	
1. Copyright Reserved		Program		01 02/11/22		BKD	
2. Work to be done shall be done only on 20m x 10m site drawing		Planning Application		Issued for LRD Planning		Project	
3. The contractor is responsible for checking all levels and dimensions on site and shall refer all discrepancies to the Architect		Fire Cert				Carlsruhe Site, Kimmage	
4. Where appropriate, for details of c. structure, or mechanical and electrical details, see Engineers drawings		Disability Cert				Residential Development	
5. Proprietary items shall be fixed in place and accordance with manufacturers instructions		Tender				Drawing Title	
6. Size of proprietary items shall be checked with manufacturer		Construction				Refuse & Bike Store Building Detail	
7. The contractor shall be responsible for the completion of drawings, signatures and stamps		As Built				Drawing No	
8. The contractor shall be responsible for the completion of drawings, signatures and stamps		Information Only		Bike Store & Refuse Store Detail		6260 LRD-P-301	
9. The contractor shall be responsible for the completion of drawings, signatures and stamps						Drawing No	
10. The contractor shall be responsible for the completion of drawings, signatures and stamps						6260 LRD-P-301	
11. The contractor shall be responsible for the completion of drawings, signatures and stamps						Scale	
12. The contractor shall be responsible for the completion of drawings, signatures and stamps						1:500 A0	
13. The contractor shall be responsible for the completion of drawings, signatures and stamps						Rev	
14. The contractor shall be responsible for the completion of drawings, signatures and stamps						01	
15. The contractor shall be responsible for the completion of drawings, signatures and stamps						Drawn	
16. The contractor shall be responsible for the completion of drawings, signatures and stamps						BKD	
17. The contractor shall be responsible for the completion of drawings, signatures and stamps						Date	
18. The contractor shall be responsible for the completion of drawings, signatures and stamps						26/08/21	