





KEYPLAN
0 1500
P-000

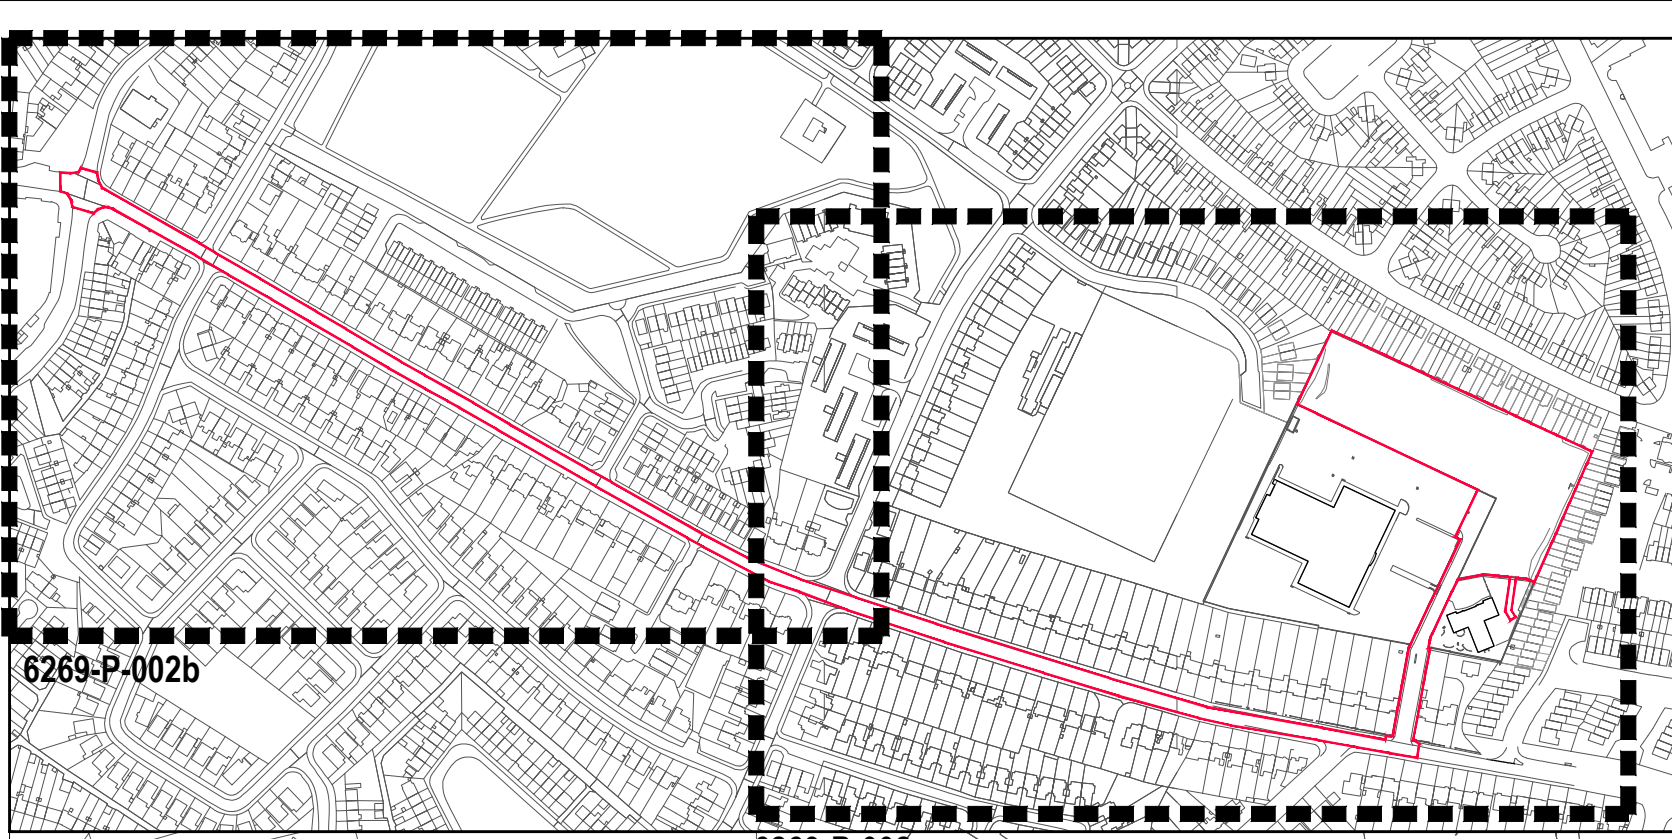

Notes:
1. Copyright Reserved
2. Work to be done in accordance with the approved plans and specifications.
3. The contractor is responsible for obtaining all necessary permits and approvals.
4. Where appropriate, for details of e.s. structure, or mechanical and electrical details, see Engineers drawings.
5. Proprietary items shall be used in accordance with manufacturers instructions.
6. Sites of preliminary items shall be checked with the relevant authorities.
7. The contractor shall be responsible for the coordination of structure, finishes and services.
8. The contractor shall be responsible for the coordination of structure, finishes and services.
9. The contractor shall be responsible for the coordination of structure, finishes and services.
10. The contractor shall be responsible for the coordination of structure, finishes and services.

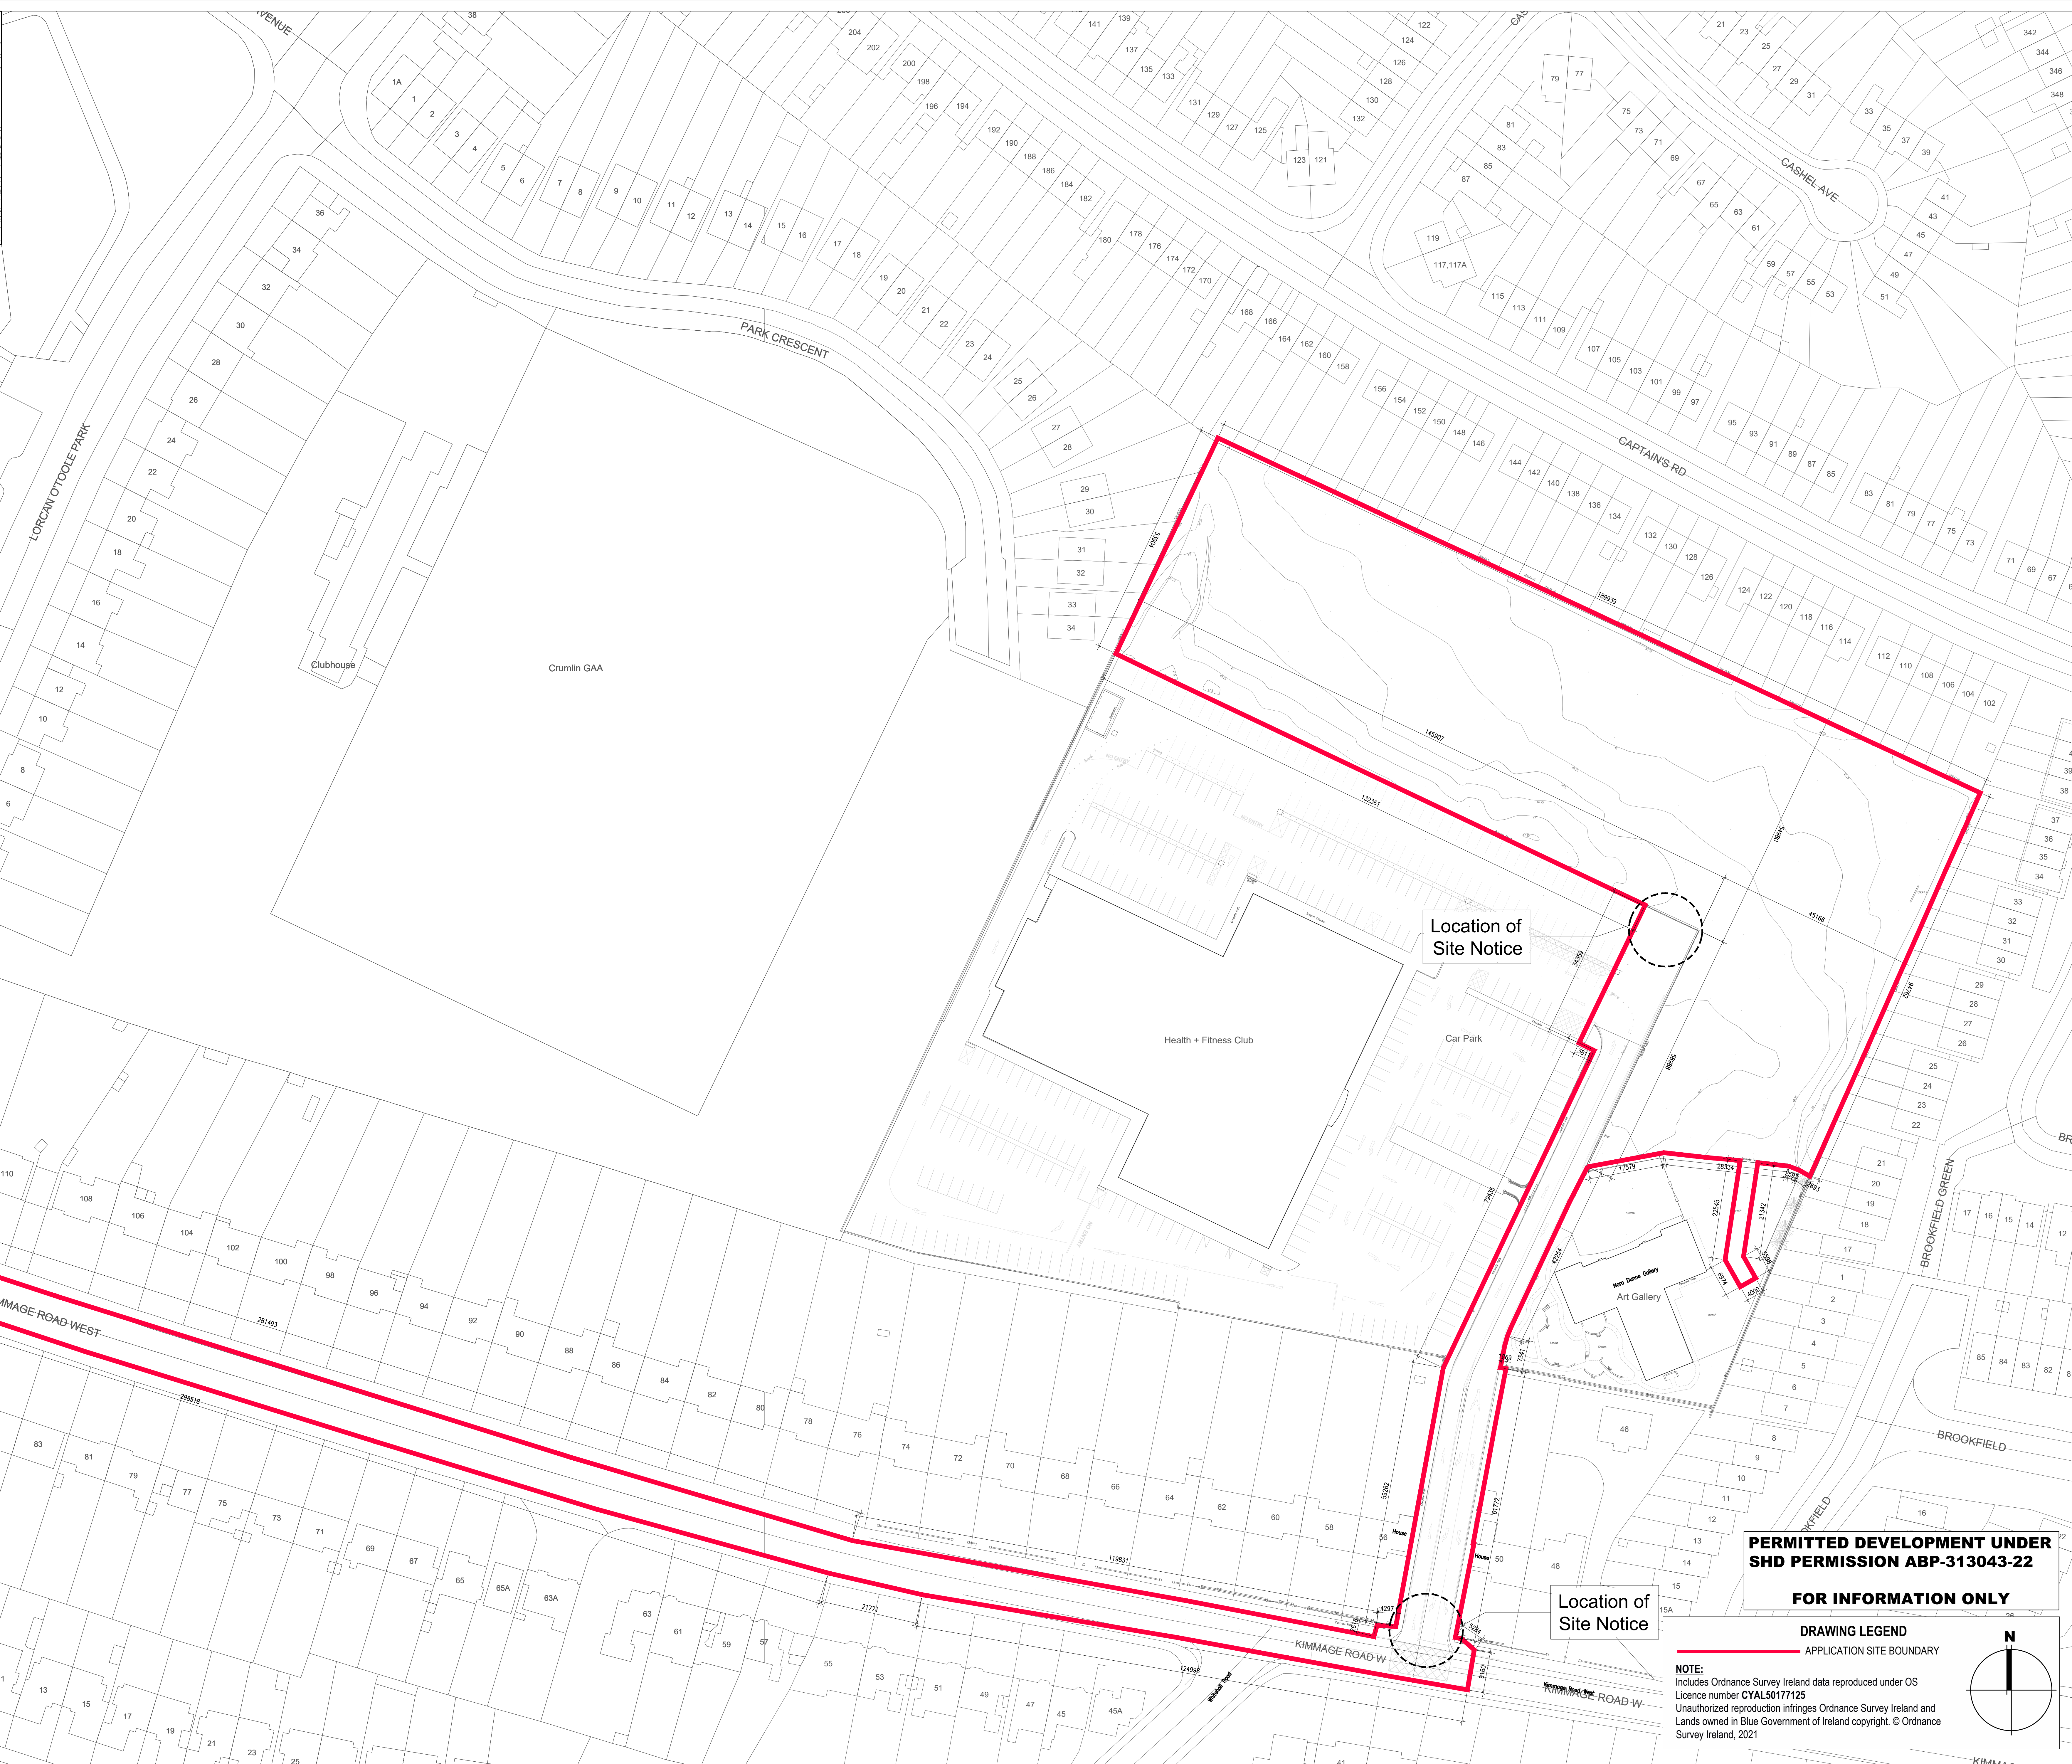

Issue Matrix
Progress
Planning Application
Final Cert
Disability Cert
Type Cert
Construction
As Built
Information Only
Existing Site Plan
Drawing Title: Existing Site Layout Plan - Sheet 1/2 (Permitted)
Drawing No: 6269-P-002a
Scale: 1:500 @ A0
Rev: 01
Drawn: BKD
Date: Oct 21
Project: Carlisle Site, Kimmage Residential Development
Licence number: CYAL50177125
Unauthorized reproduction infringes Ordnance Survey Ireland and Lands owned in Blue Government of Ireland copyright. © Ordnance Survey Ireland, 2021
bkd architects
BURREN-SHERIDAN DOYLE