




1 Proposed Context Elevation - North
1 : 500



2 Proposed Context Elevation - South
1 : 500




3 Proposed Context Elevation - East
1 : 500

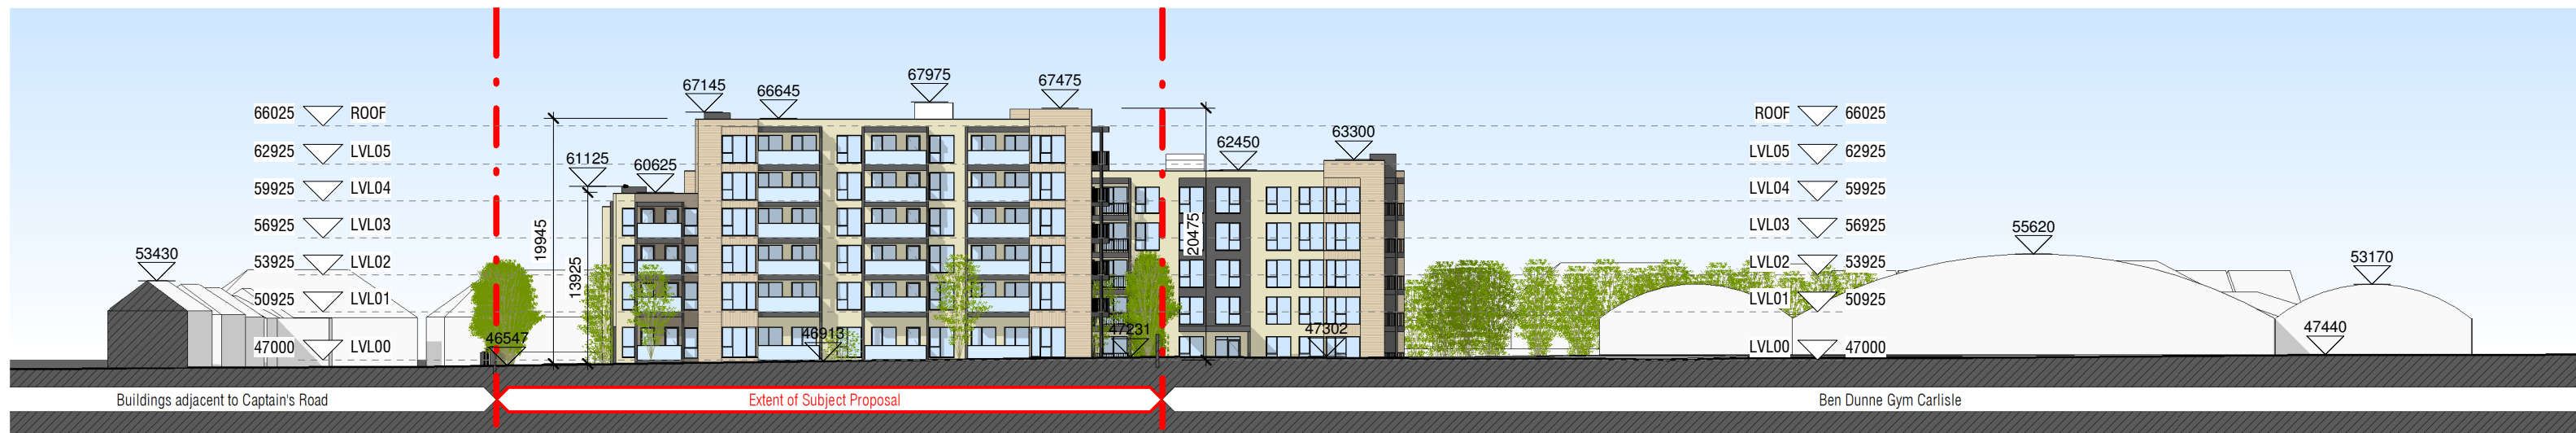

4 Proposed Context Elevation - West
1 : 500

**PERMITTED DEVELOPMENT UNDER
SHD PERMISSION ABP-313043-22**

FOR INFORMATION ONLY

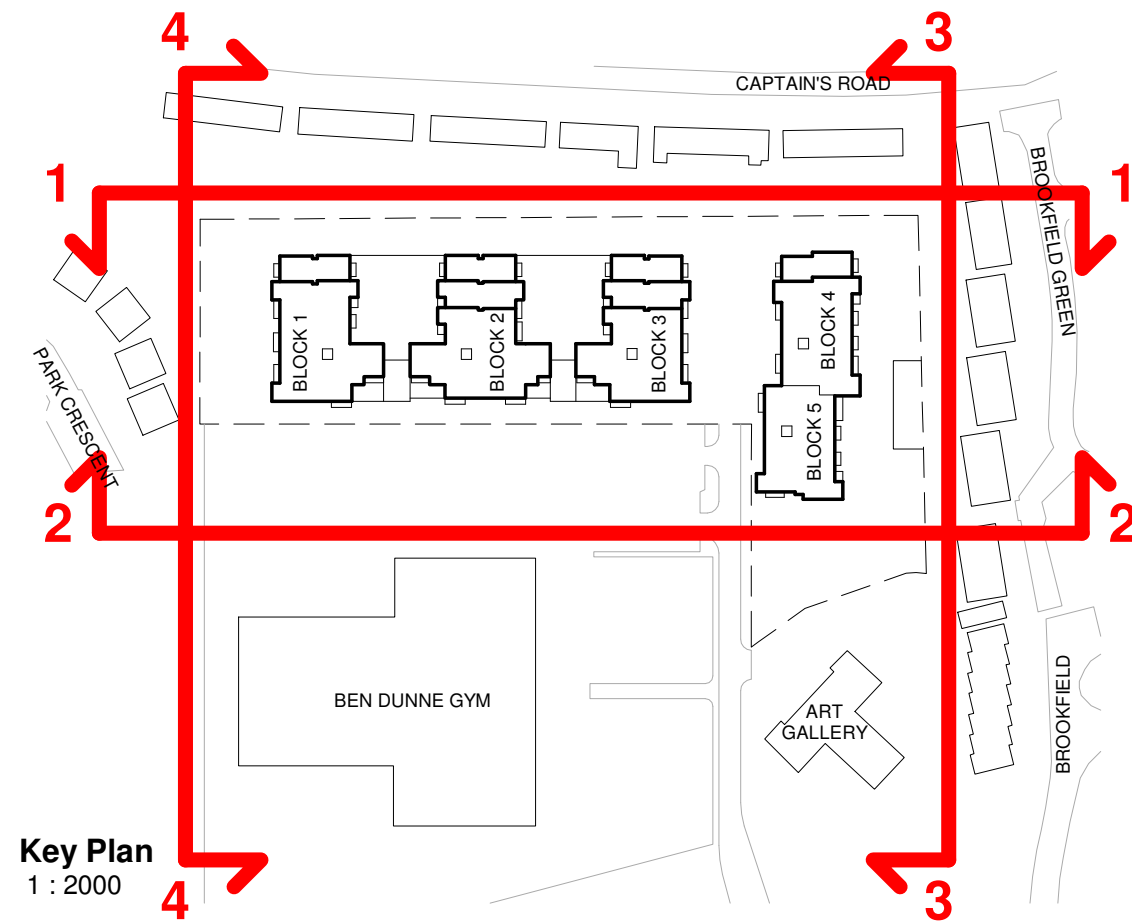

Notes
1. Copyright Reserved
2. Work to figured dimensions only. Do not scale drawing.
3. The contractor is responsible for checking all levels and dimensions on site and shall refer all discrepancies to the Architect
4. Where appropriate, for details of r.c. structure, or mechanical and electrical details, see Engineers drawings
5. Proprietary items shall be fixed in strict accordance with manufacturers instructions.
6. Sizes of proprietary items shall be checked with manufacturer.
7. The contractor shall be responsible for the coordination of structure, finishes and services.

Issue Status
Progress
Planning Application
Fire Cert
Disability Cert
Tender
Construction
As Built
Information Only

No.	Date	Revision	Issued
1	02/11/22	Issued for information only	BKD

Project	Carlisle Site Residential Development 52-54 Kimmage Rd West, Kimmage, Dublin 12		
Drawing Title	Permitted Contiguous Elevations		
Drawing No	6269 - P - 060		
Scale	1:500@A1	Rev	1
Drawn	BKD	Date	Oct 2021

6-7 HARCOURT TERRACE, DUBLIN 2, IRELAND
t + 353-1-618 2400 f + 353-1-678 7385
www.bkd.ie
bkdarchitects
B R U K E - K E E N E D Y D O Y L E