


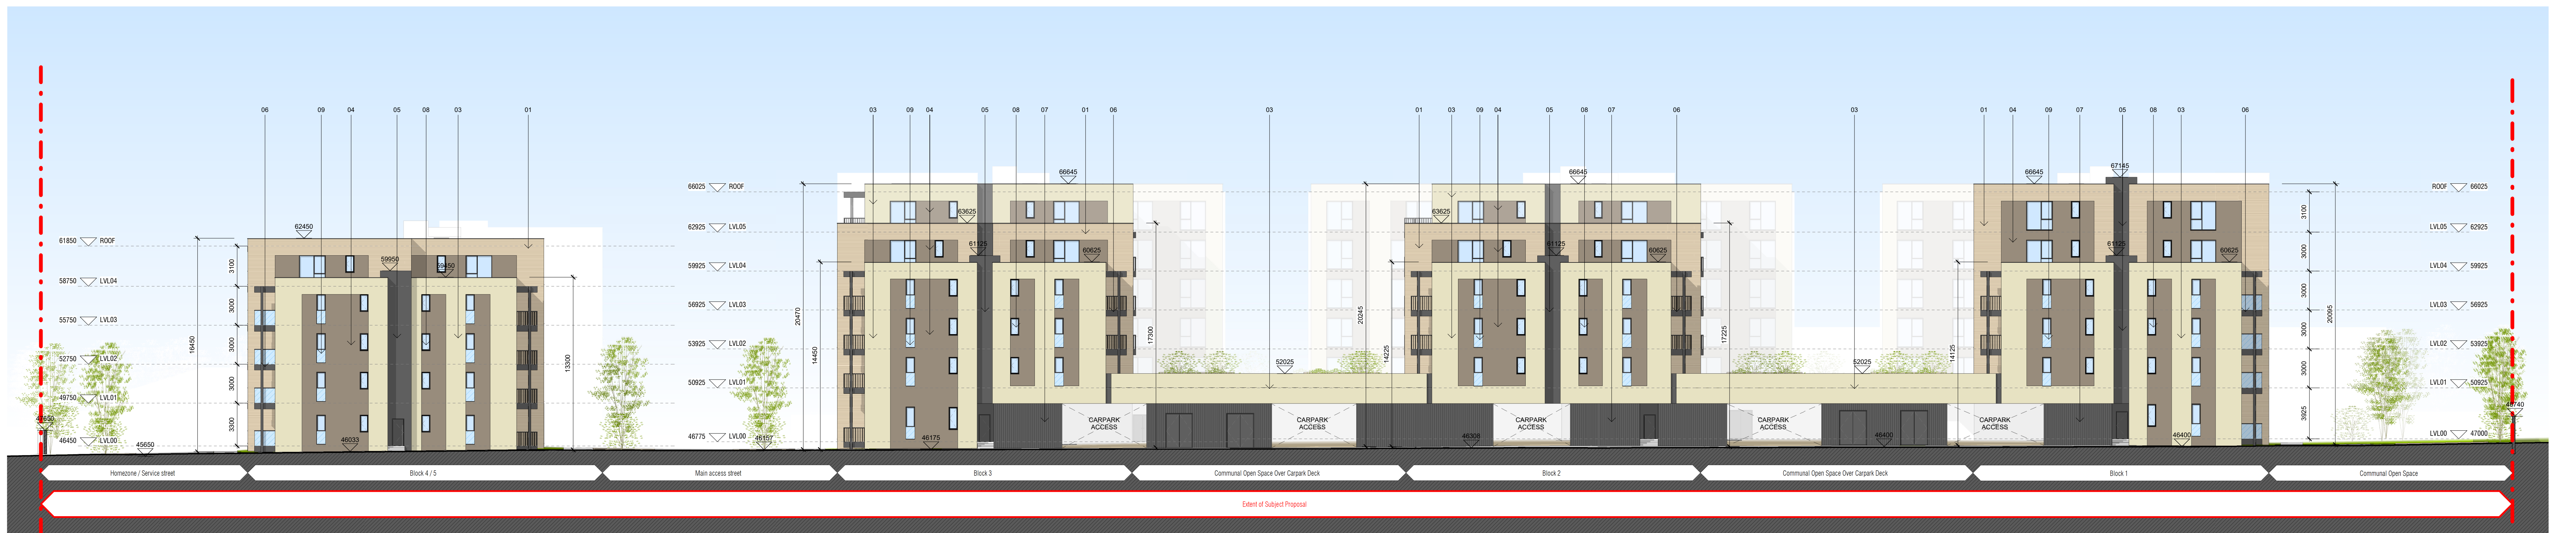

1 Site Elevation - South
1 : 200



2 Site Elevation - North
1 : 200


MATERIAL CODE LEGEND	
01 - BUFF BRICK - STANDARD BOND - LIGHT SAND TONE	
02 - BUFF BRICK - FEATURE BOND - LIGHT SAND TONE	
03 - SELF COLOURED RENDER - CREAM / OFF-WHITE TONE	
04 - SELF COLOURED RENDER - PALE BROWN / TAN TONE	
05 - SELF COLOURED RENDER - DARK GREY / CHARCOAL TONE	
06 - POWDERCOATED METALWORK - DARK GREY / CHARCOAL TONE	
07 - POWDERCOATED METAL SCREENING - DARK GREY / CHARCOAL TONE	
08 - CLEAR GLAZING WITH DARK GREY / CHARCOAL TONE FRAMING	
09 - OPACIFIED GLAZING WITH DARK GREY / CHARCOAL TONE FRAMING TO A HEIGHT OF 1200mm ABOVE FLOOR LEVEL	

Notes
1. Copyright Reserved
2. Work to fixed dimensions only. Do not scale drawing.
3. The contractor is responsible for checking all levels and dimensions on site and shall refer all discrepancies to the Architect.
4. Where appropriate, for details of r.c. structure, or mechanical and electrical details, see Engineers drawings.
5. Proprietary items shall be fixed in strict accordance with manufacturers instructions.
6. Space of proprietary items shall be checked with manufacturer.
7. The contractor shall be responsible for the coordination of structure, finishes and services.
As Built
Information Only

Issue Status
Progress
Planning Application
Fire Cert
Disability Cert
Tender
Construction
As Built
Information Only

**PERMITTED DEVELOPMENT UNDER
SHD PERMISSION ABP-313043-22**

FOR INFORMATION ONLY

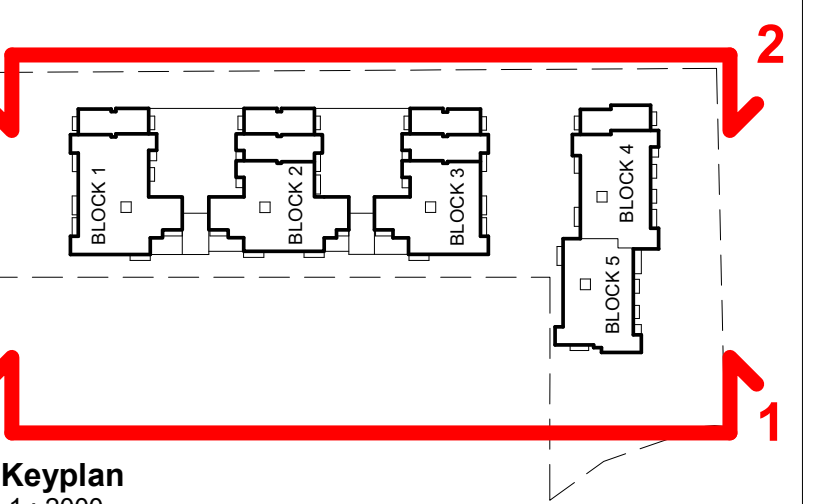

Keyplan
1 : 2000

Project: Carlisle Site Residential Development
62-64 Kimmage Rd West, Kimmage, Dublin 12
Drawing Title: Permitted Site Elevations - North & South
Drawing No: 6269 - P - 150
Scale: 1:200 @ A0
Rev: 1
Drawn: BKD
Date: Oct 2021
bkdarchitects
BRUCE-KERRYBOYLES