



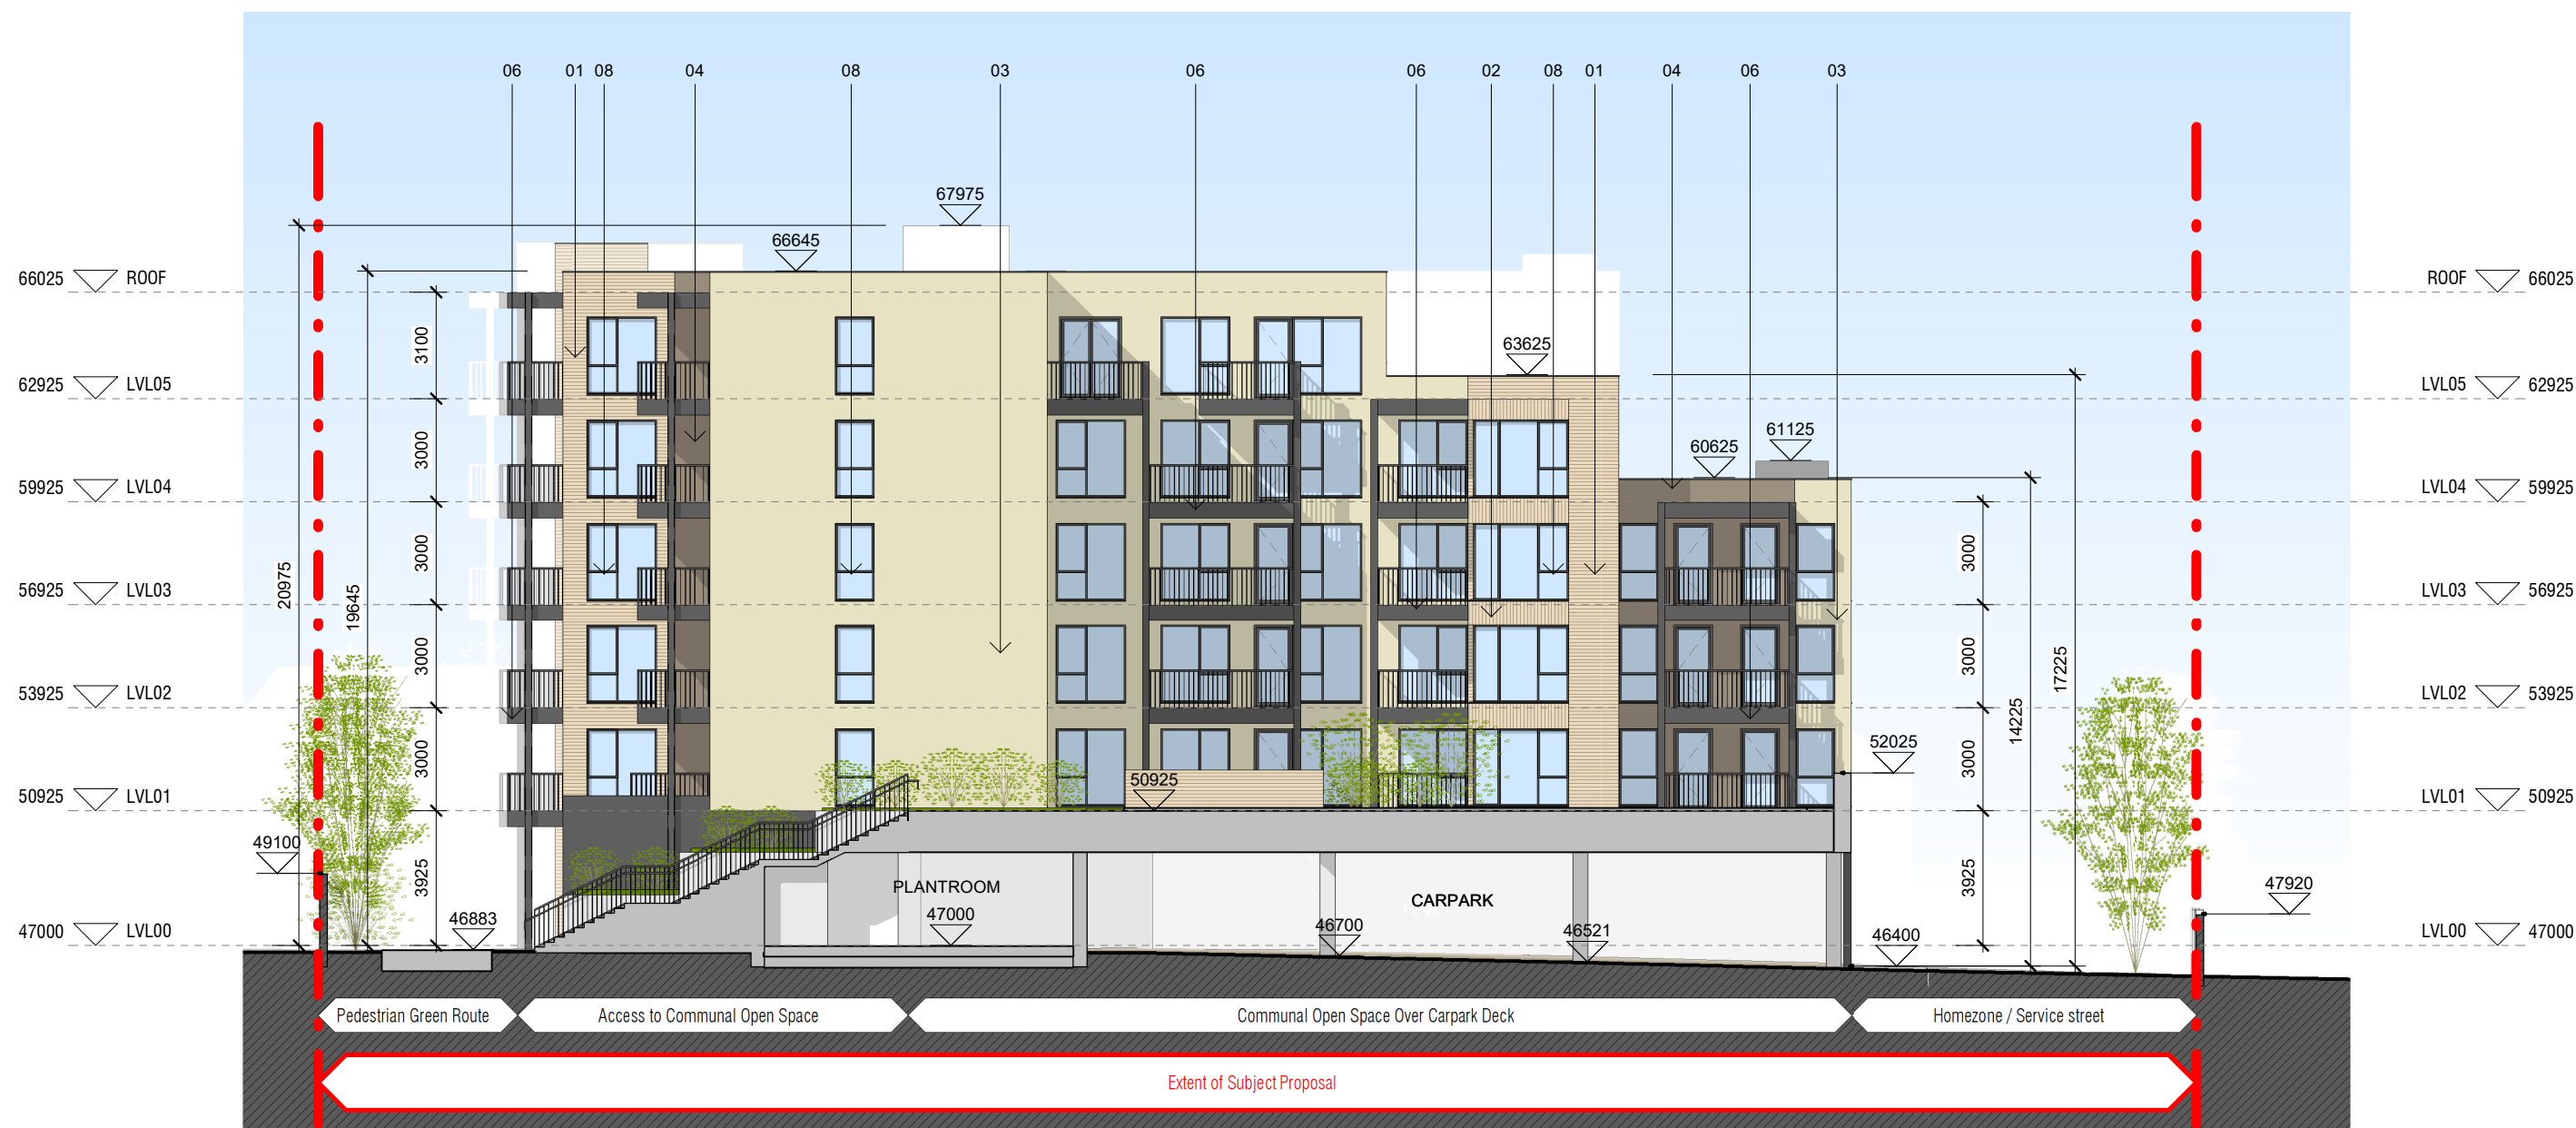

1 Site Elevations - Block2 East Elevation
1 : 200

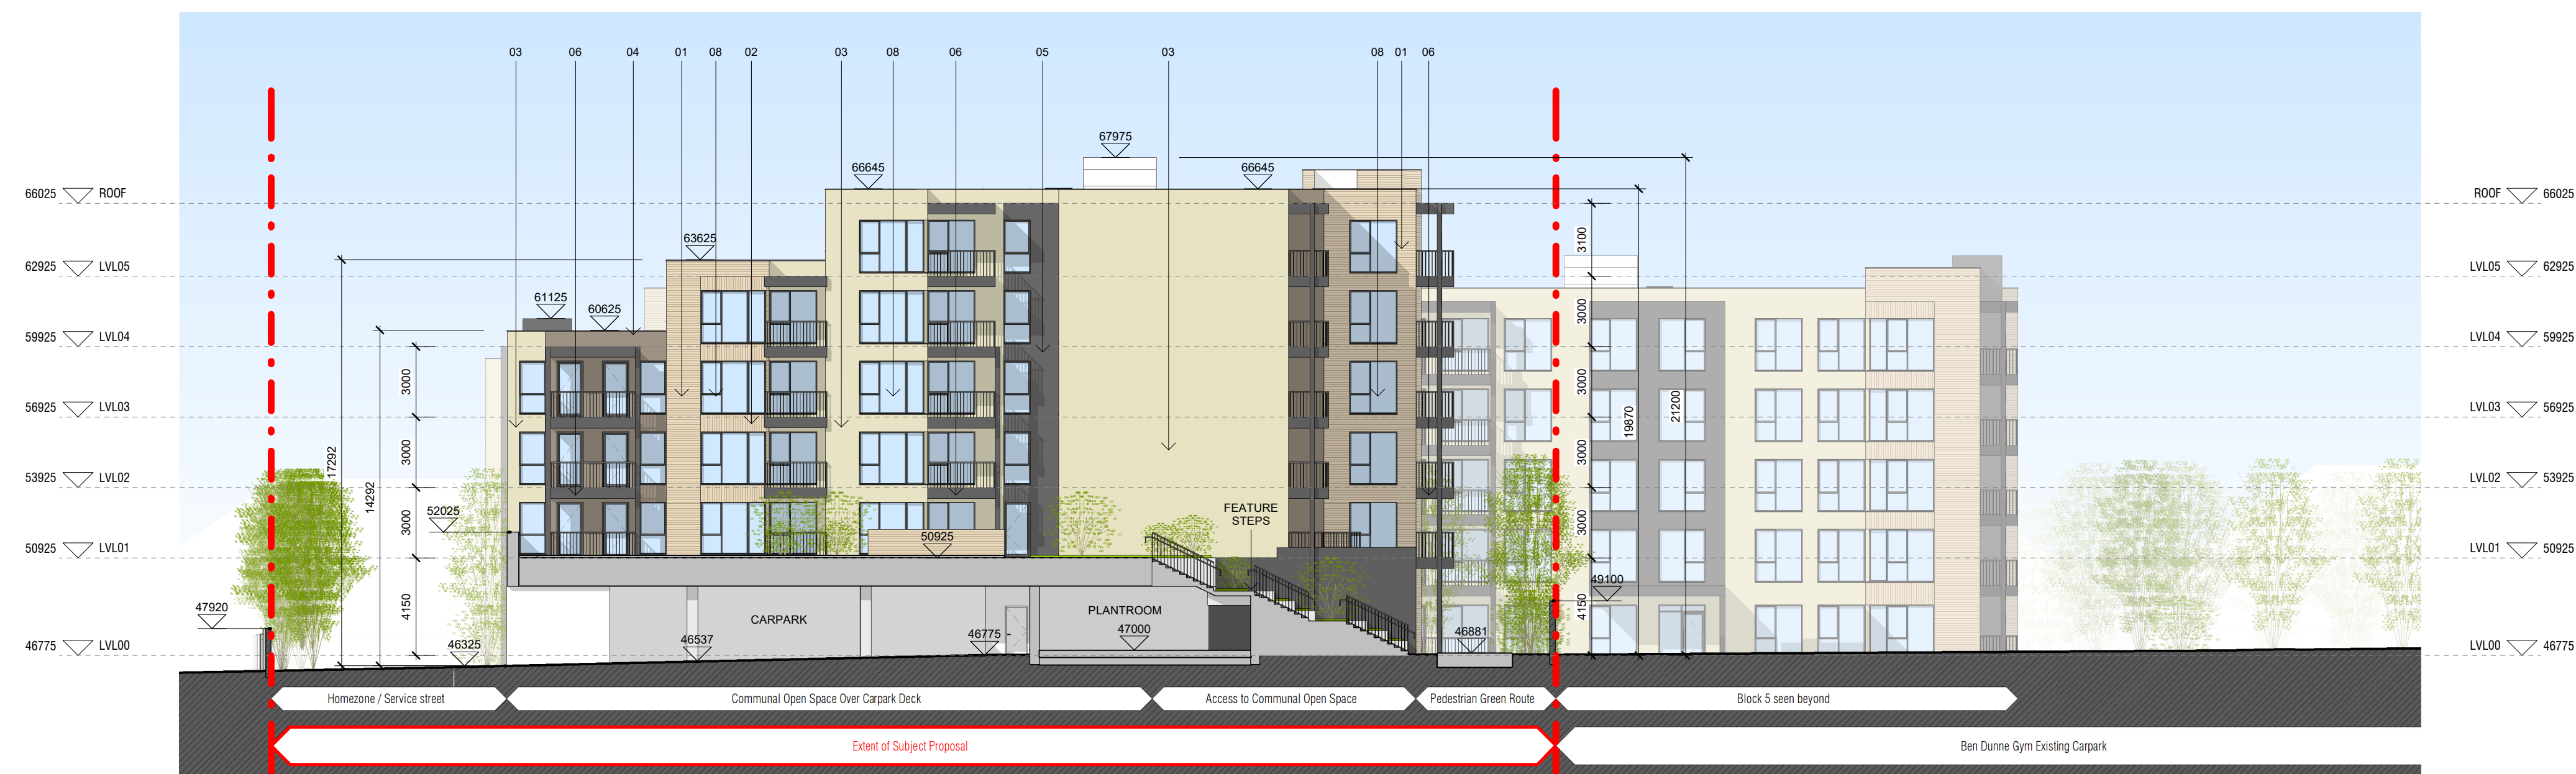


2 Site Elevations - Block3 West Elevation
1 : 200

MATERIAL CODE LEGEND

- 01 - BUFF BRICK - STANDARD BOND - LIGHT SAND TONE
- 02 - BUFF BRICK - FEATURE BOND - LIGHT SAND TONE
- 03 - SELF COLOURED RENDER - CREAM / OFF-WHITE TONE
- 04 - SELF COLOURED RENDER - PALE BROWN / TAN TONE
- 05 - SELF COLOURED RENDER - DARK GREY / CHARCOAL TONE
- 06 - POWDERCOATED METALWORK - DARK GREY / CHARCOAL TONE
- 07 - POWDERCOATED METAL SCREENING - DARK GREY / CHARCOAL TONE
- 08 - CLEAR GLAZING WITH DARK GREY / CHARCOAL TONE FRAMING
- 09 - OPACIFIED GLAZING WITH DARK GREY / CHARCOAL TONE FRAMING TO A HEIGHT OF 1200mm ABOVE FLOOR LEVEL

**PERMITTED DEVELOPMENT UNDER
SHD PERMISSION ABP-313043-22**

FOR INFORMATION ONLY

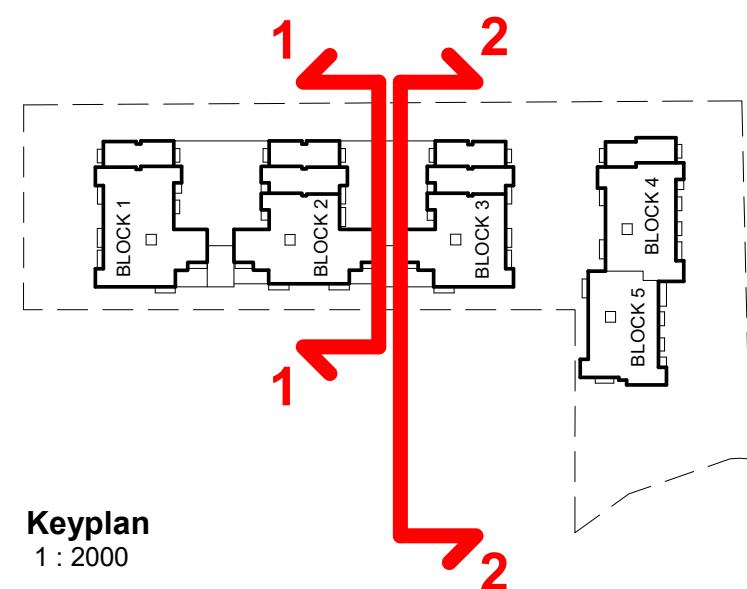

Keyplan
1 : 2000

Notes
1. Copyright Reserved
2. Work to figured dimensions only. Do not scale drawing.
3. The contractor is responsible for checking all levels and dimensions on site and shall refer all discrepancies to the Architect.
4. Where appropriate, for details of r.c. structure, or mechanical and electrical details, see Engineers drawings.
5. Proprietary items shall be fixed in strict accordance with manufacturers instructions.
6. Sizes of proprietary items shall be checked with manufacturer.
7. The contractor shall be responsible for the coordination of structure, finishes and services.

Issue Status
Progress
Planning Application
Fire Cert
Disability Cert
Tender
Construction
As Built
Information Only

No.	Date	Revision	Issued
1	02/11/22	Issued for information only	BKD

Project	Carlisle Site Residential Development 52-54 Kimmage Rd West, Kimmage, Dublin 12
Drawing Title	Permitted Site Elevations - Internal Elevations - Sheet 2/3
Drawing No	6269 - P - 153
Scale	1:200@A1
Rev	1
Drawn	BKD
Date	Oct 2021

6-7 HARCOURT TERRACE, DUBLIN 2, IRELAND
t +353-1-618 2400 f +353-1-678 7385
www.bkd.ie
bkdarchitects
B U R K E - K E E N E D Y D O Y L E