




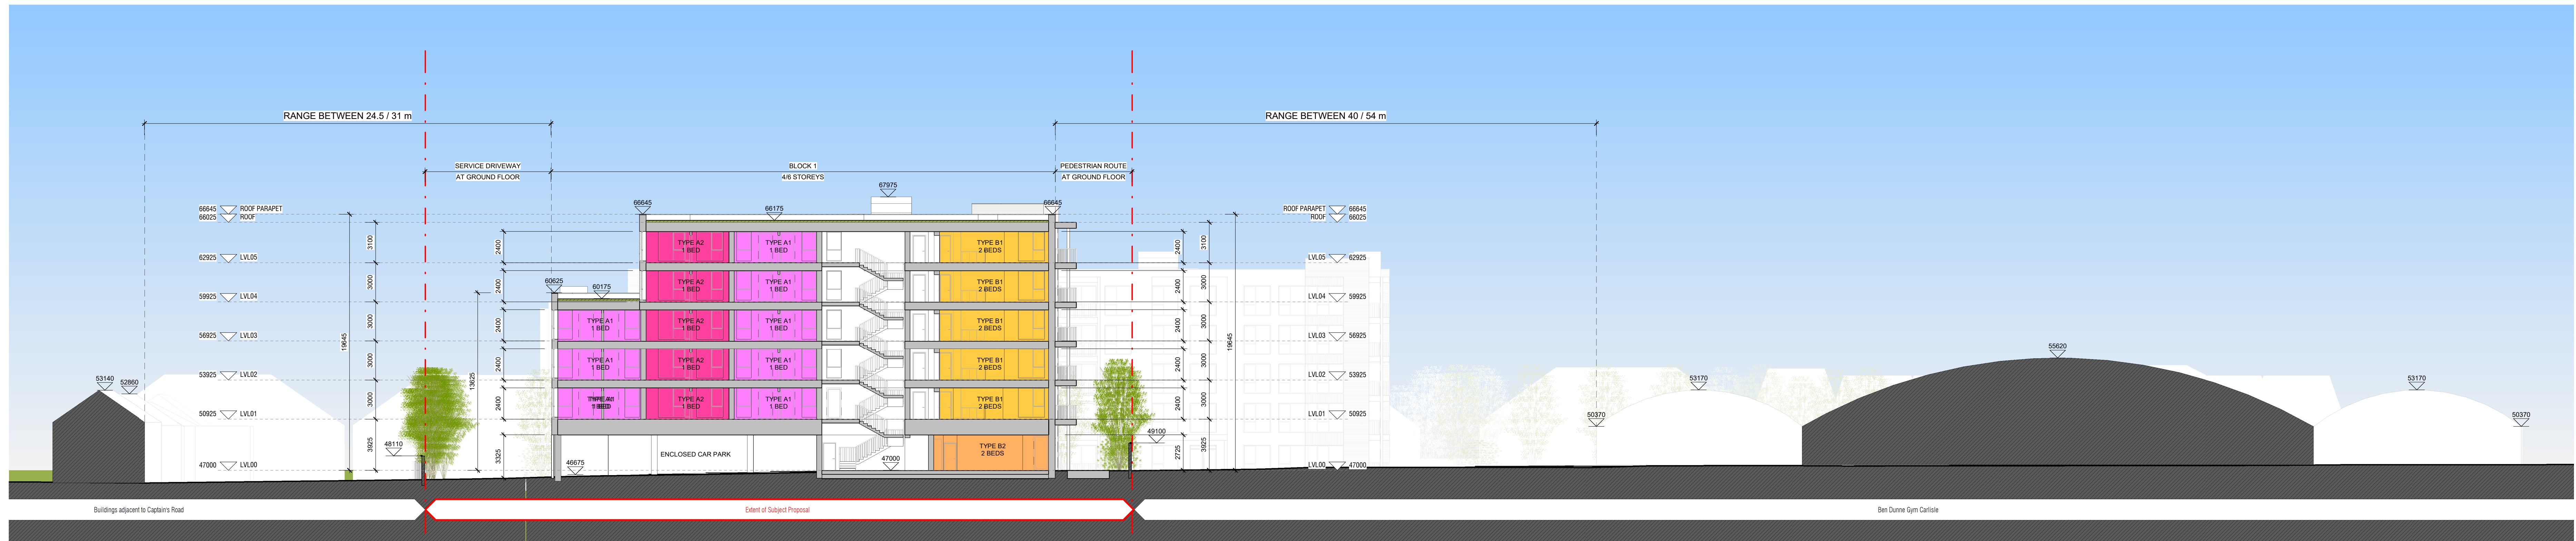

A Site Sections - Section A-A
1:200

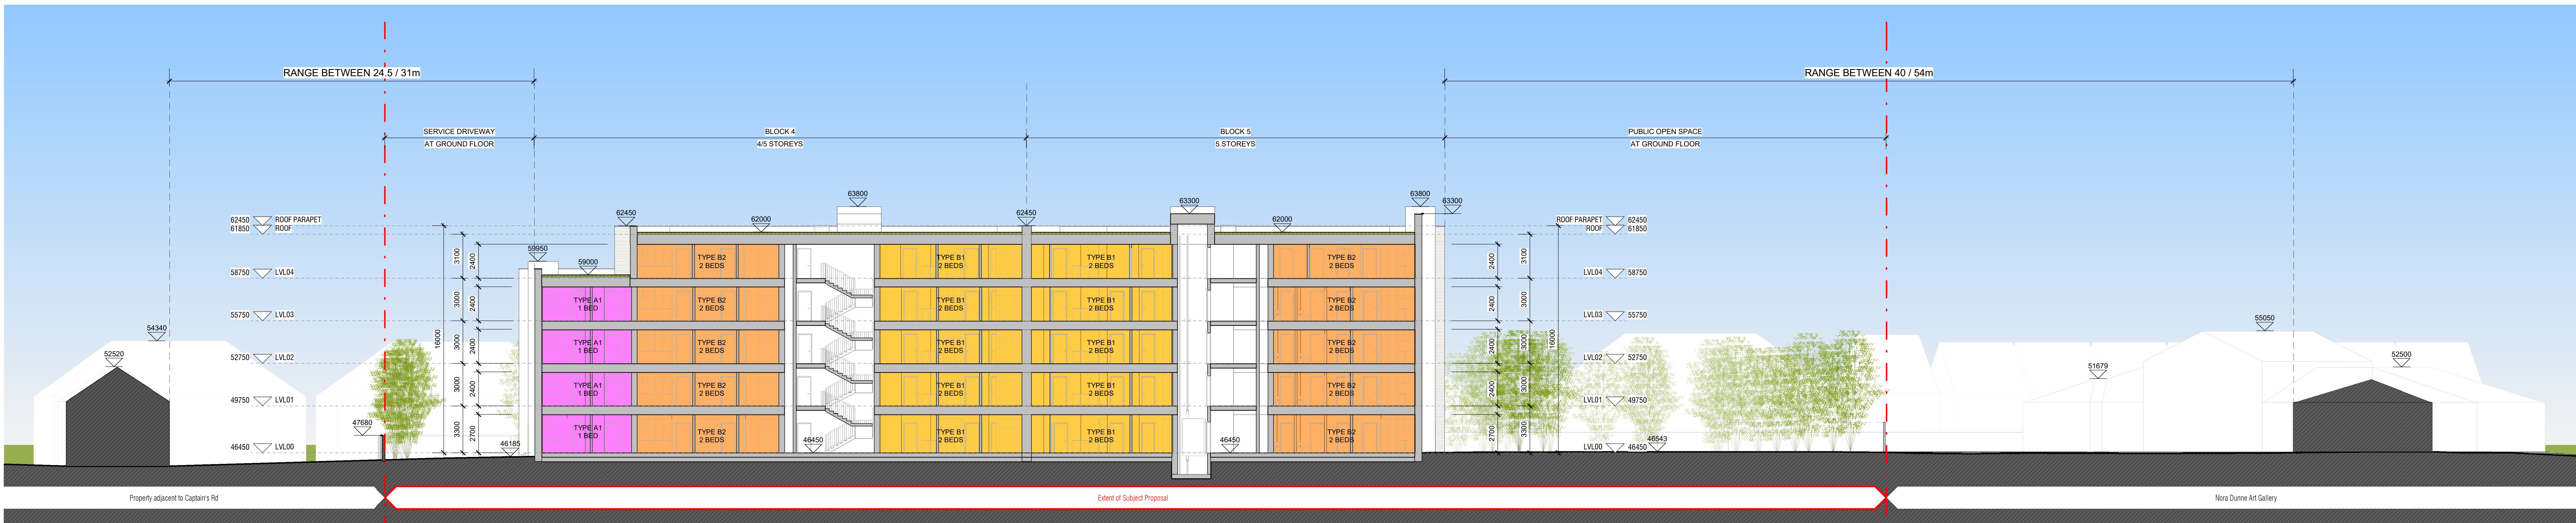


B Site Sections - Section B-B
1:200

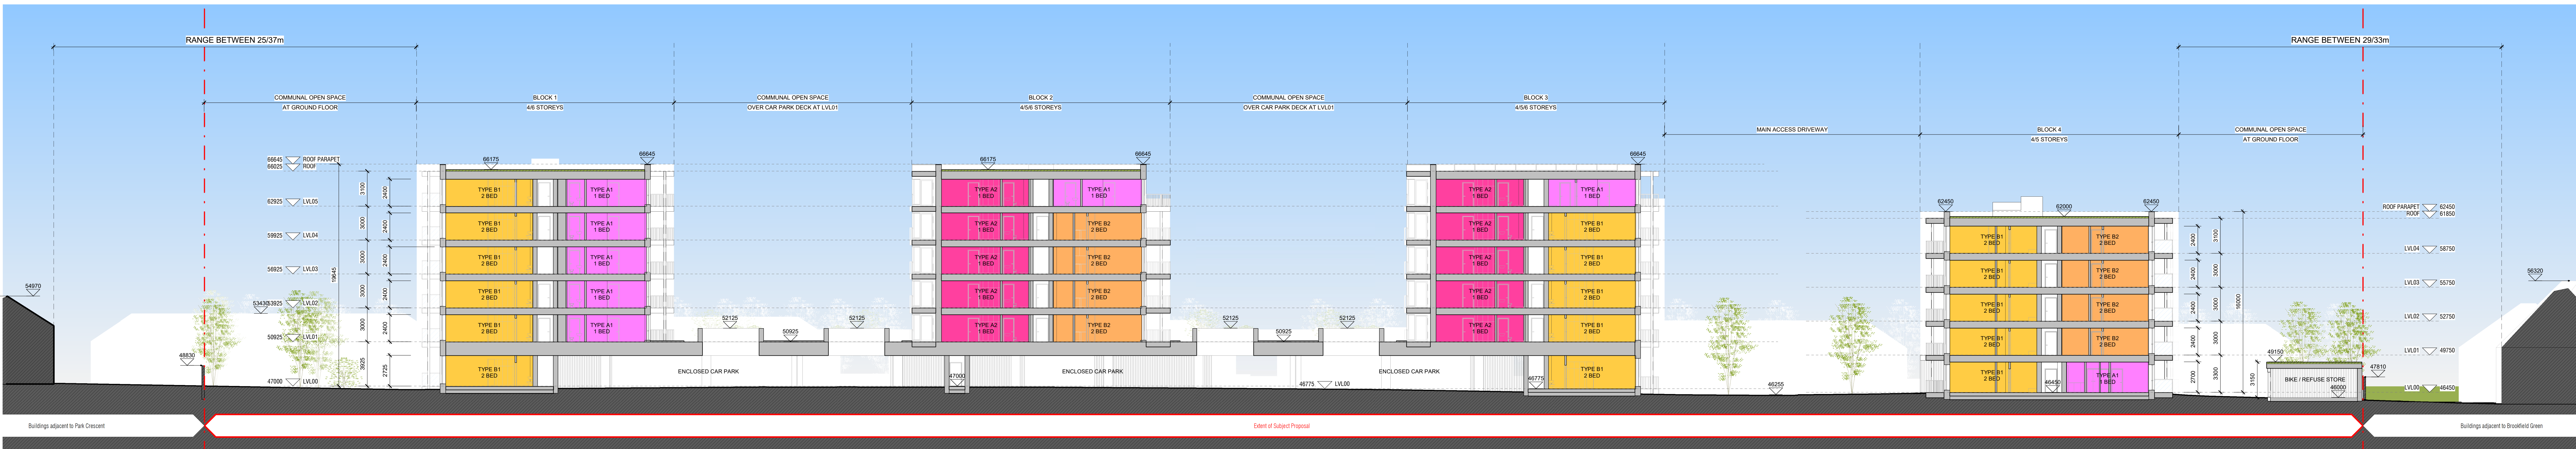

C Site Sections - Section C-C
1:200

**PERMITTED DEVELOPMENT UNDER
SHD PERMISSION ABP-313043-22**

FOR INFORMATION ONLY

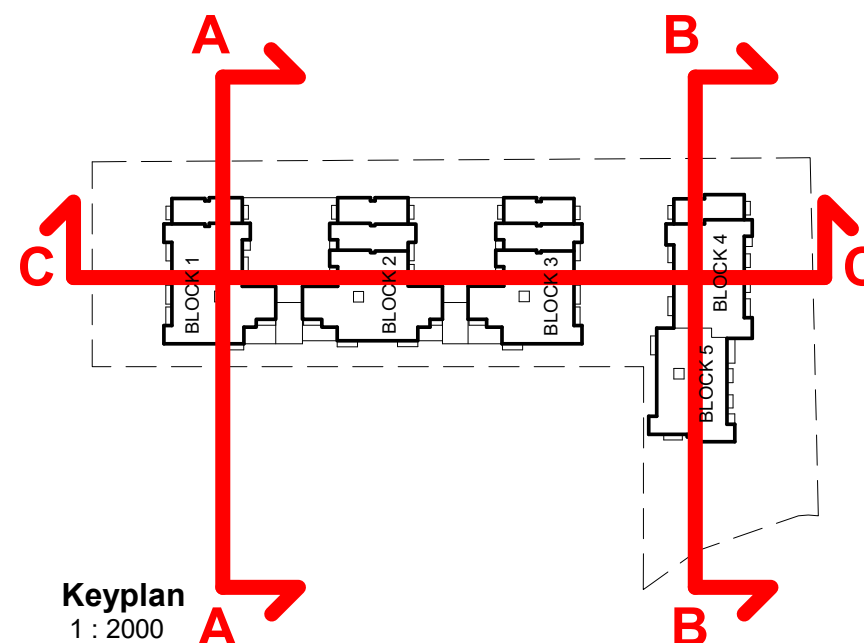

Notes:
1. Copyright Reserved
2. Work to signed dimensions only. Do not scale drawings.
3. The contractor is responsible for checking all levels and dimensions on site and shall refer all discrepancies to the Architect.
4. Where appropriate, for details of r.c. structure, or mechanical and electrical details, see Engineers drawings.
5. Proprietary items shall be fixed in strict accordance with manufacturers instructions.
6. Some of proprietary items shall be checked with manufacturer.
7. The contractor shall be responsible for the coordination of structure, finishes and services.

Issue Status
Progress
Planning Application
Final Comm.
Disability Cert
Tender
Construction
As Built
Information Only

Project: Carlisle Site Residential Development
62-64 Kimmage Rd West, Kimmage, Dublin 12
Drawing Title: Permitted Sections
Drawing No: 6269 - P - 160
Scale: 1:200 @ A0
Rev: 1
Drawn: VF
Date: Oct 2021

6-7 PHANCOURT TERRACE, DUBLIN 2, IRELAND
+353 1 616 3600 / +353 1 676 7880
www.bkd.ie
bkd architects
BRIAN KERRY DOYLE