


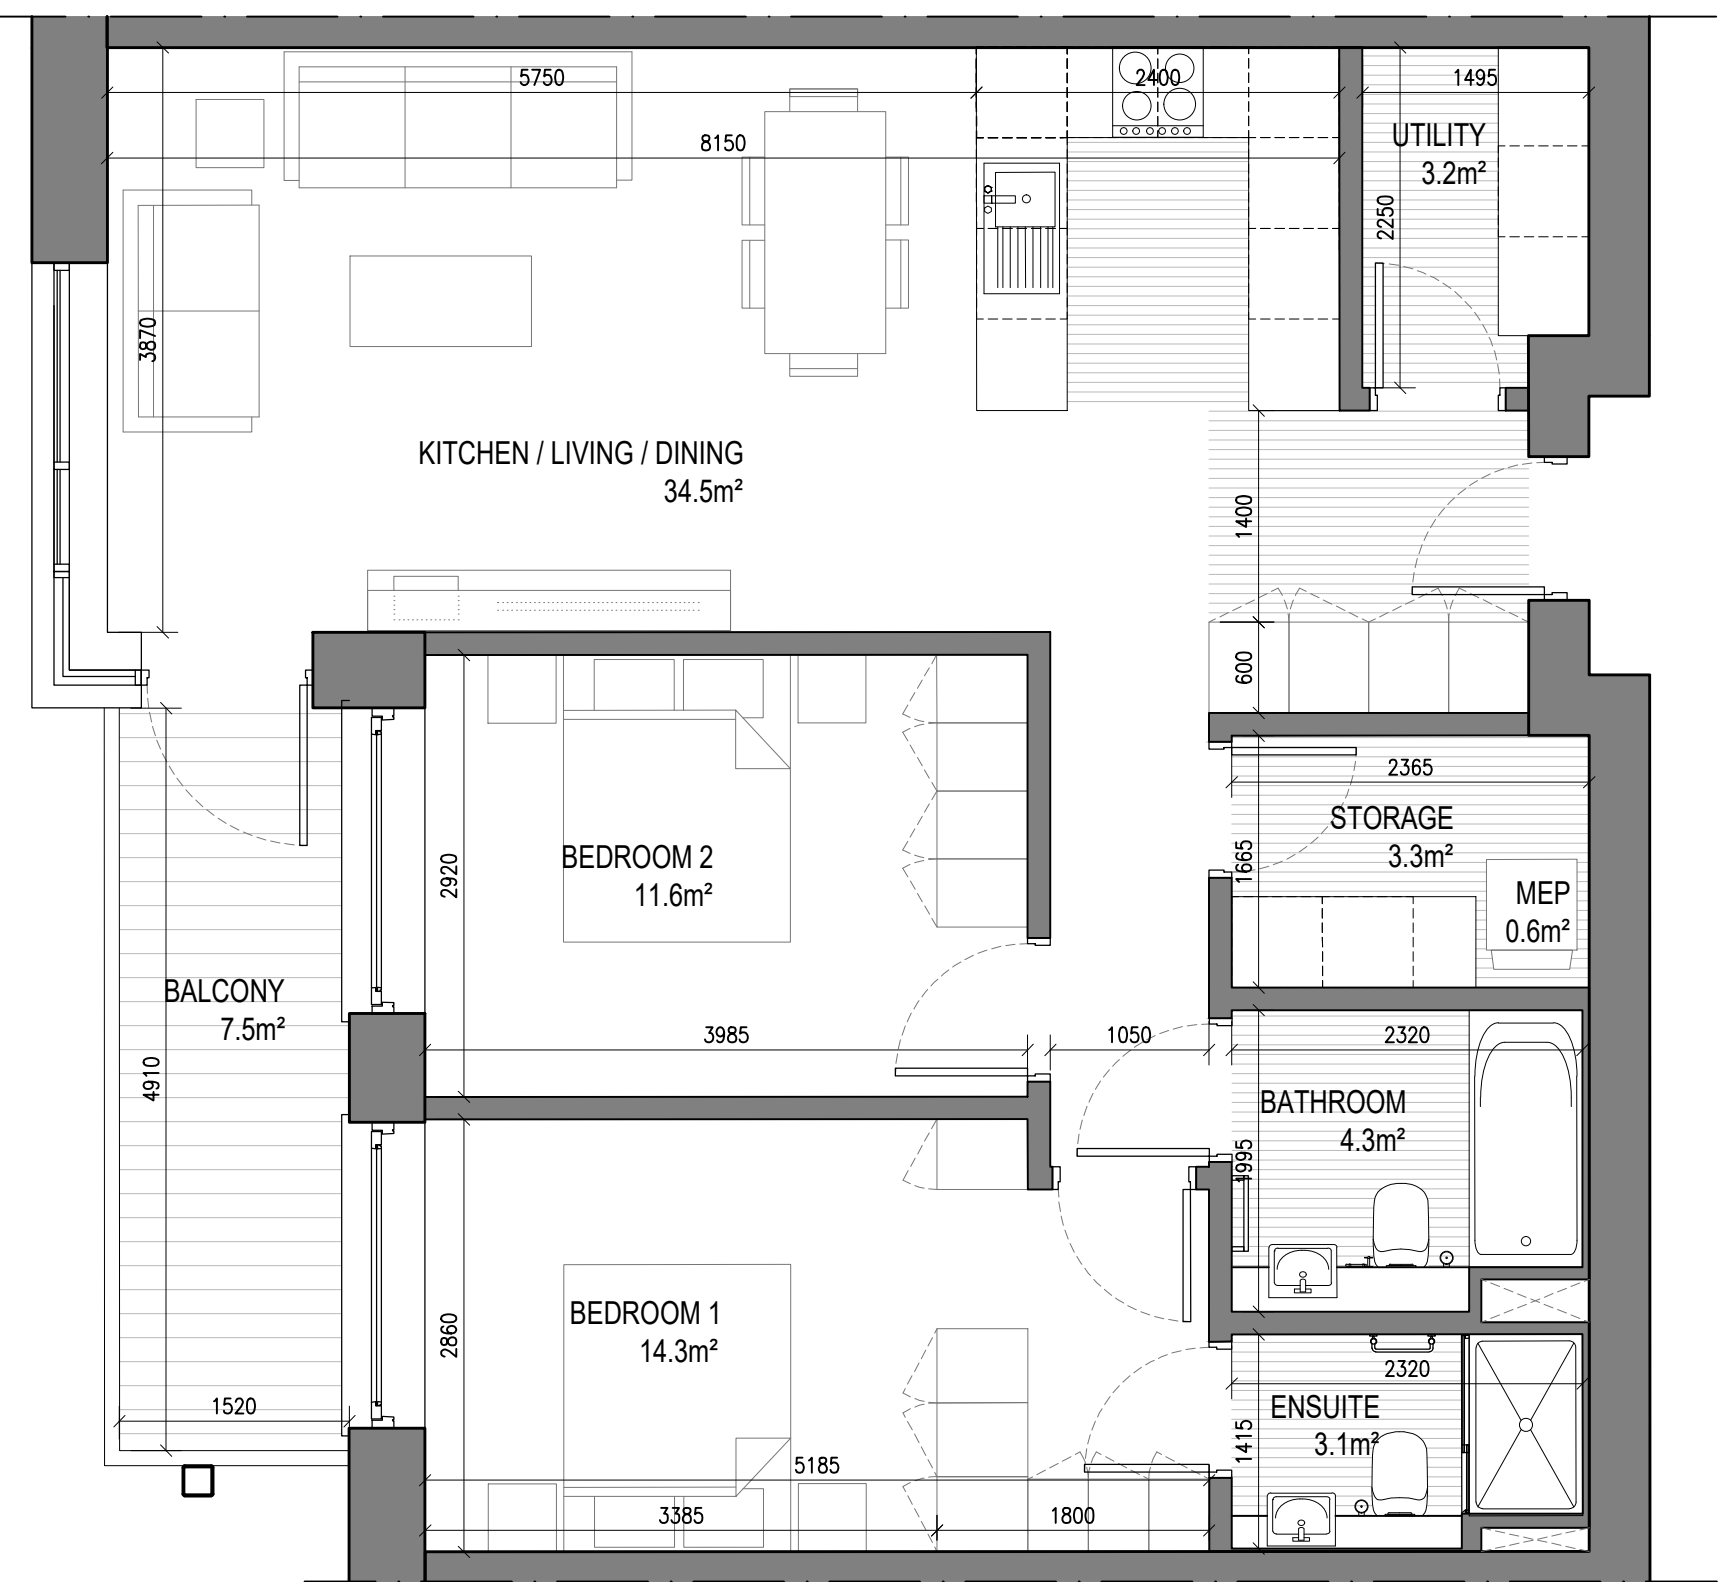


UNIT TYPE B2.1

2 Beds Unit - Floor Area: 83.68m²

SCALE 1:50

NOTE: 1. UNITS 505, 515, 525, 535 & 545 LAYOUT IS MIRRORED NORTH TO SOUTH
2. UNITS 302, 312, 322, 332 & 341 LAYOUT IS MIRRORED EAST TO WEST
3. UNITS 415, 425, 435 & 445 LAYOUT IS ROTATED 180 DEGREES

	REQUIRED [m²]	PROVIDED [m²]
STORAGE SPACE	6.0	6.5
PRIVATE AMENITY SPACE	7.0	7.5
AGGREGATE BEDROOM AREA	24.4	25.9
AGGREGATE KITCHEN / LIVING / DINING	30.0	34.5

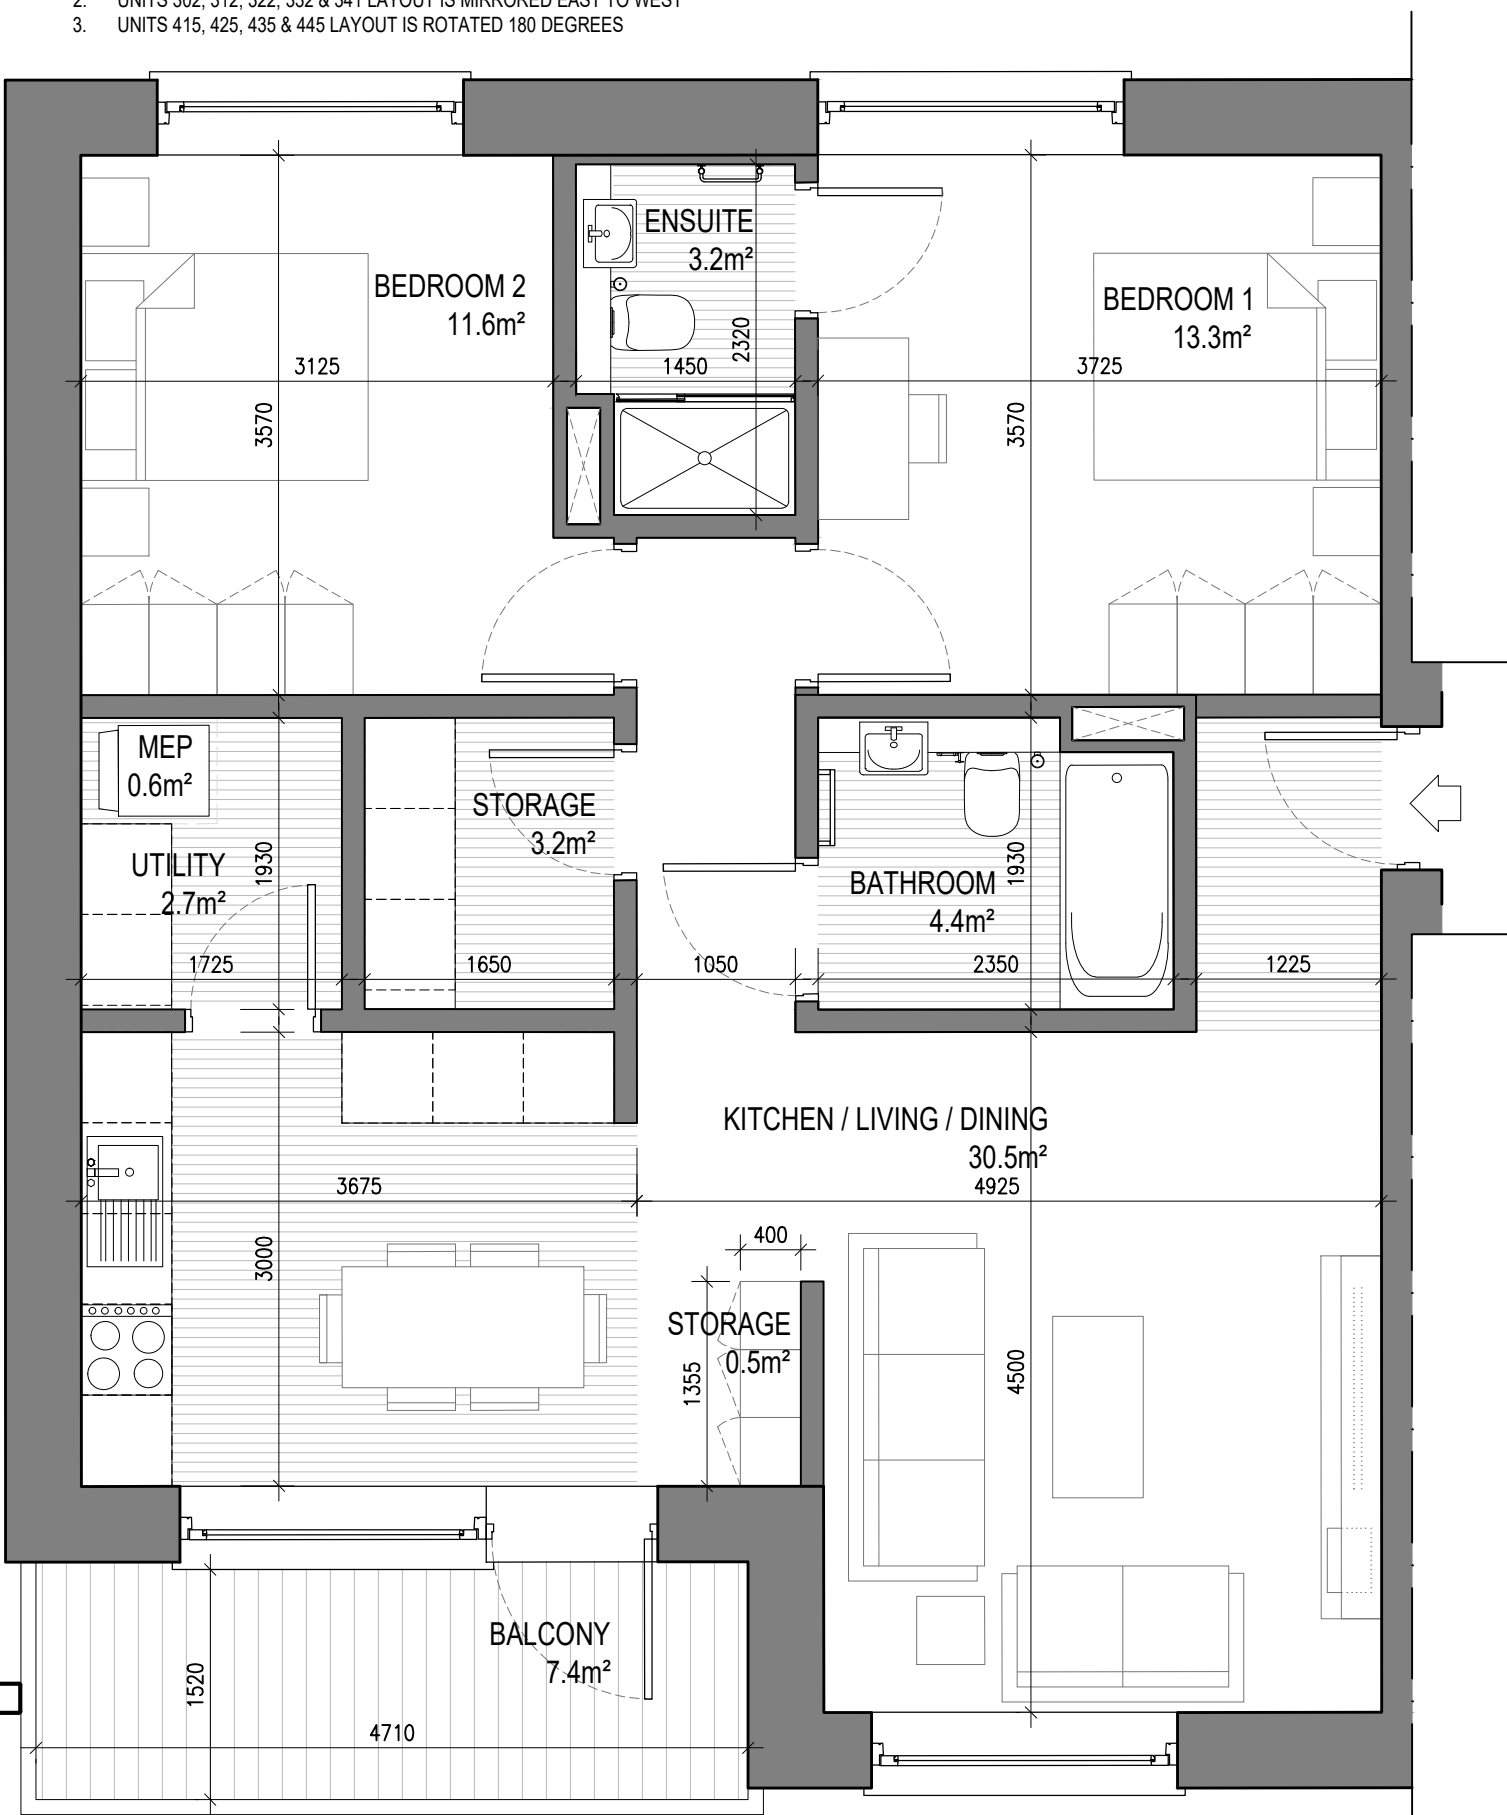


UNIT TYPE B2.2

2 Beds Unit - Floor Area: 81.22m²

SCALE 1:50

NOTE: UNITS 111, 121, 131, 141 & 151 LAYOUT IS MIRRORED EAST TO WEST

	REQUIRED [m²]	PROVIDED [m²]
STORAGE SPACE	6.0	6.4
PRIVATE AMENITY SPACE	7.0	7.4
AGGREGATE BEDROOM AREA	24.4	24.9
AGGREGATE KITCHEN / LIVING / DINING	30.0	30.5

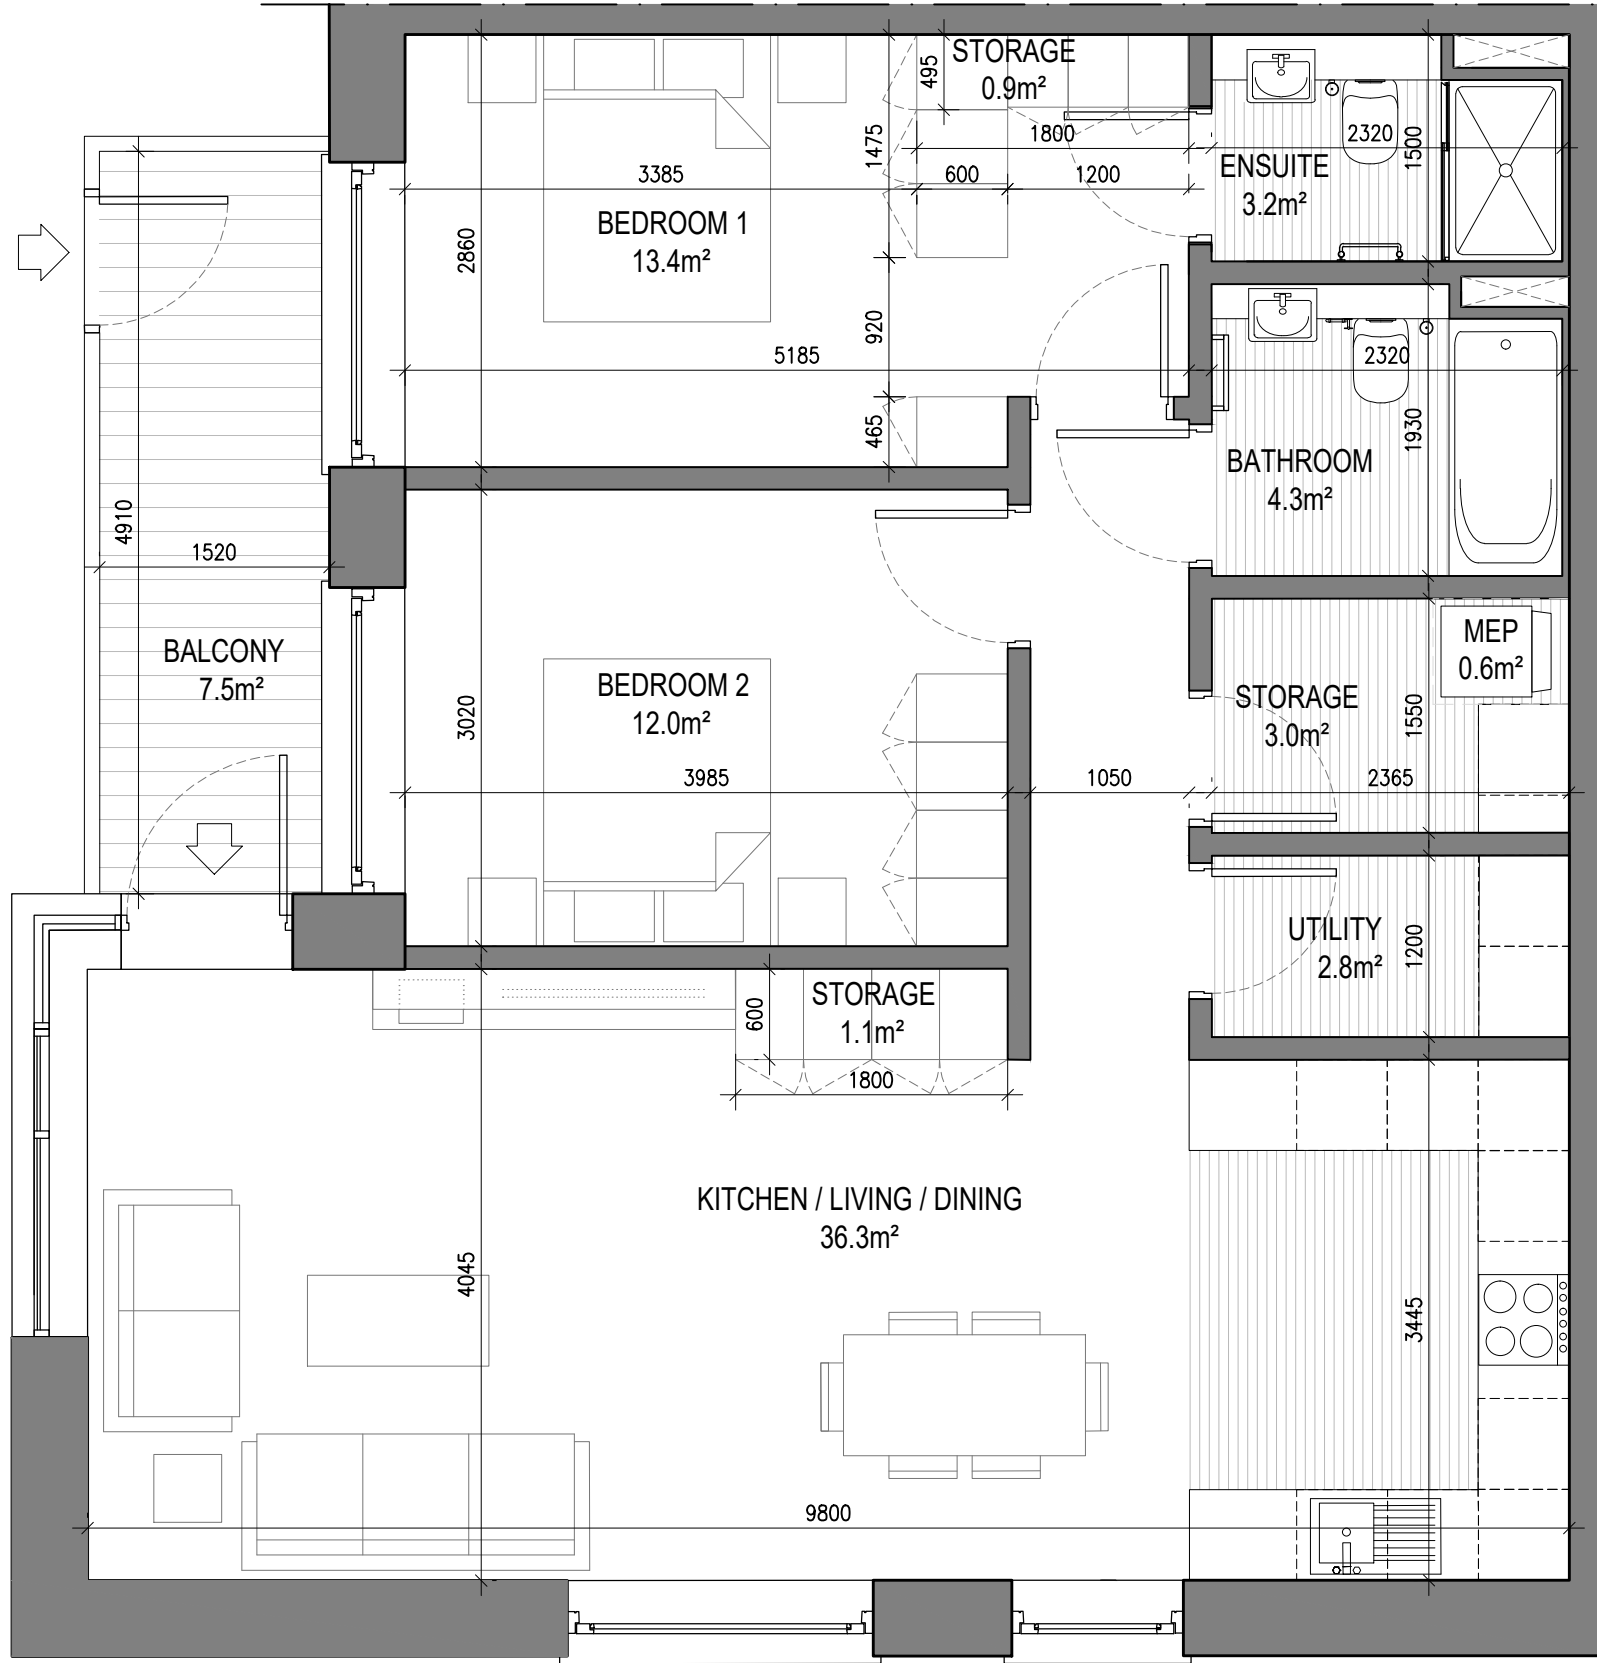

UNIT TYPE B2.4

2 Beds Unit - Floor Area: 87.19m²

SCALE 1:50

NOTE: UNIT 304 LAYOUT IS MIRRORED EAST TO WEST

	REQUIRED [m²]	PROVIDED [m²]
STORAGE SPACE	6.0	7.8
PRIVATE AMENITY SPACE	7.0	7.5
AGGREGATE BEDROOM AREA	24.4	25.4
AGGREGATE KITCHEN / LIVING / DINING	30.0	36.3




UNIT TYPE B2.3

2 Beds Unit - Floor Area: 86.10m²

SCALE 1:50

NOTE: UNITS 314, 324, 334, 343 & 353 LAYOUT IS MIRRORED EAST TO WEST

	REQUIRED [m²]	PROVIDED [m²]
STORAGE SPACE	6.0	6.4
PRIVATE AMENITY SPACE	7.0	7.5
AGGREGATE BEDROOM AREA	24.4	24.9
AGGREGATE KITCHEN / LIVING / DINING	30.0	35.5

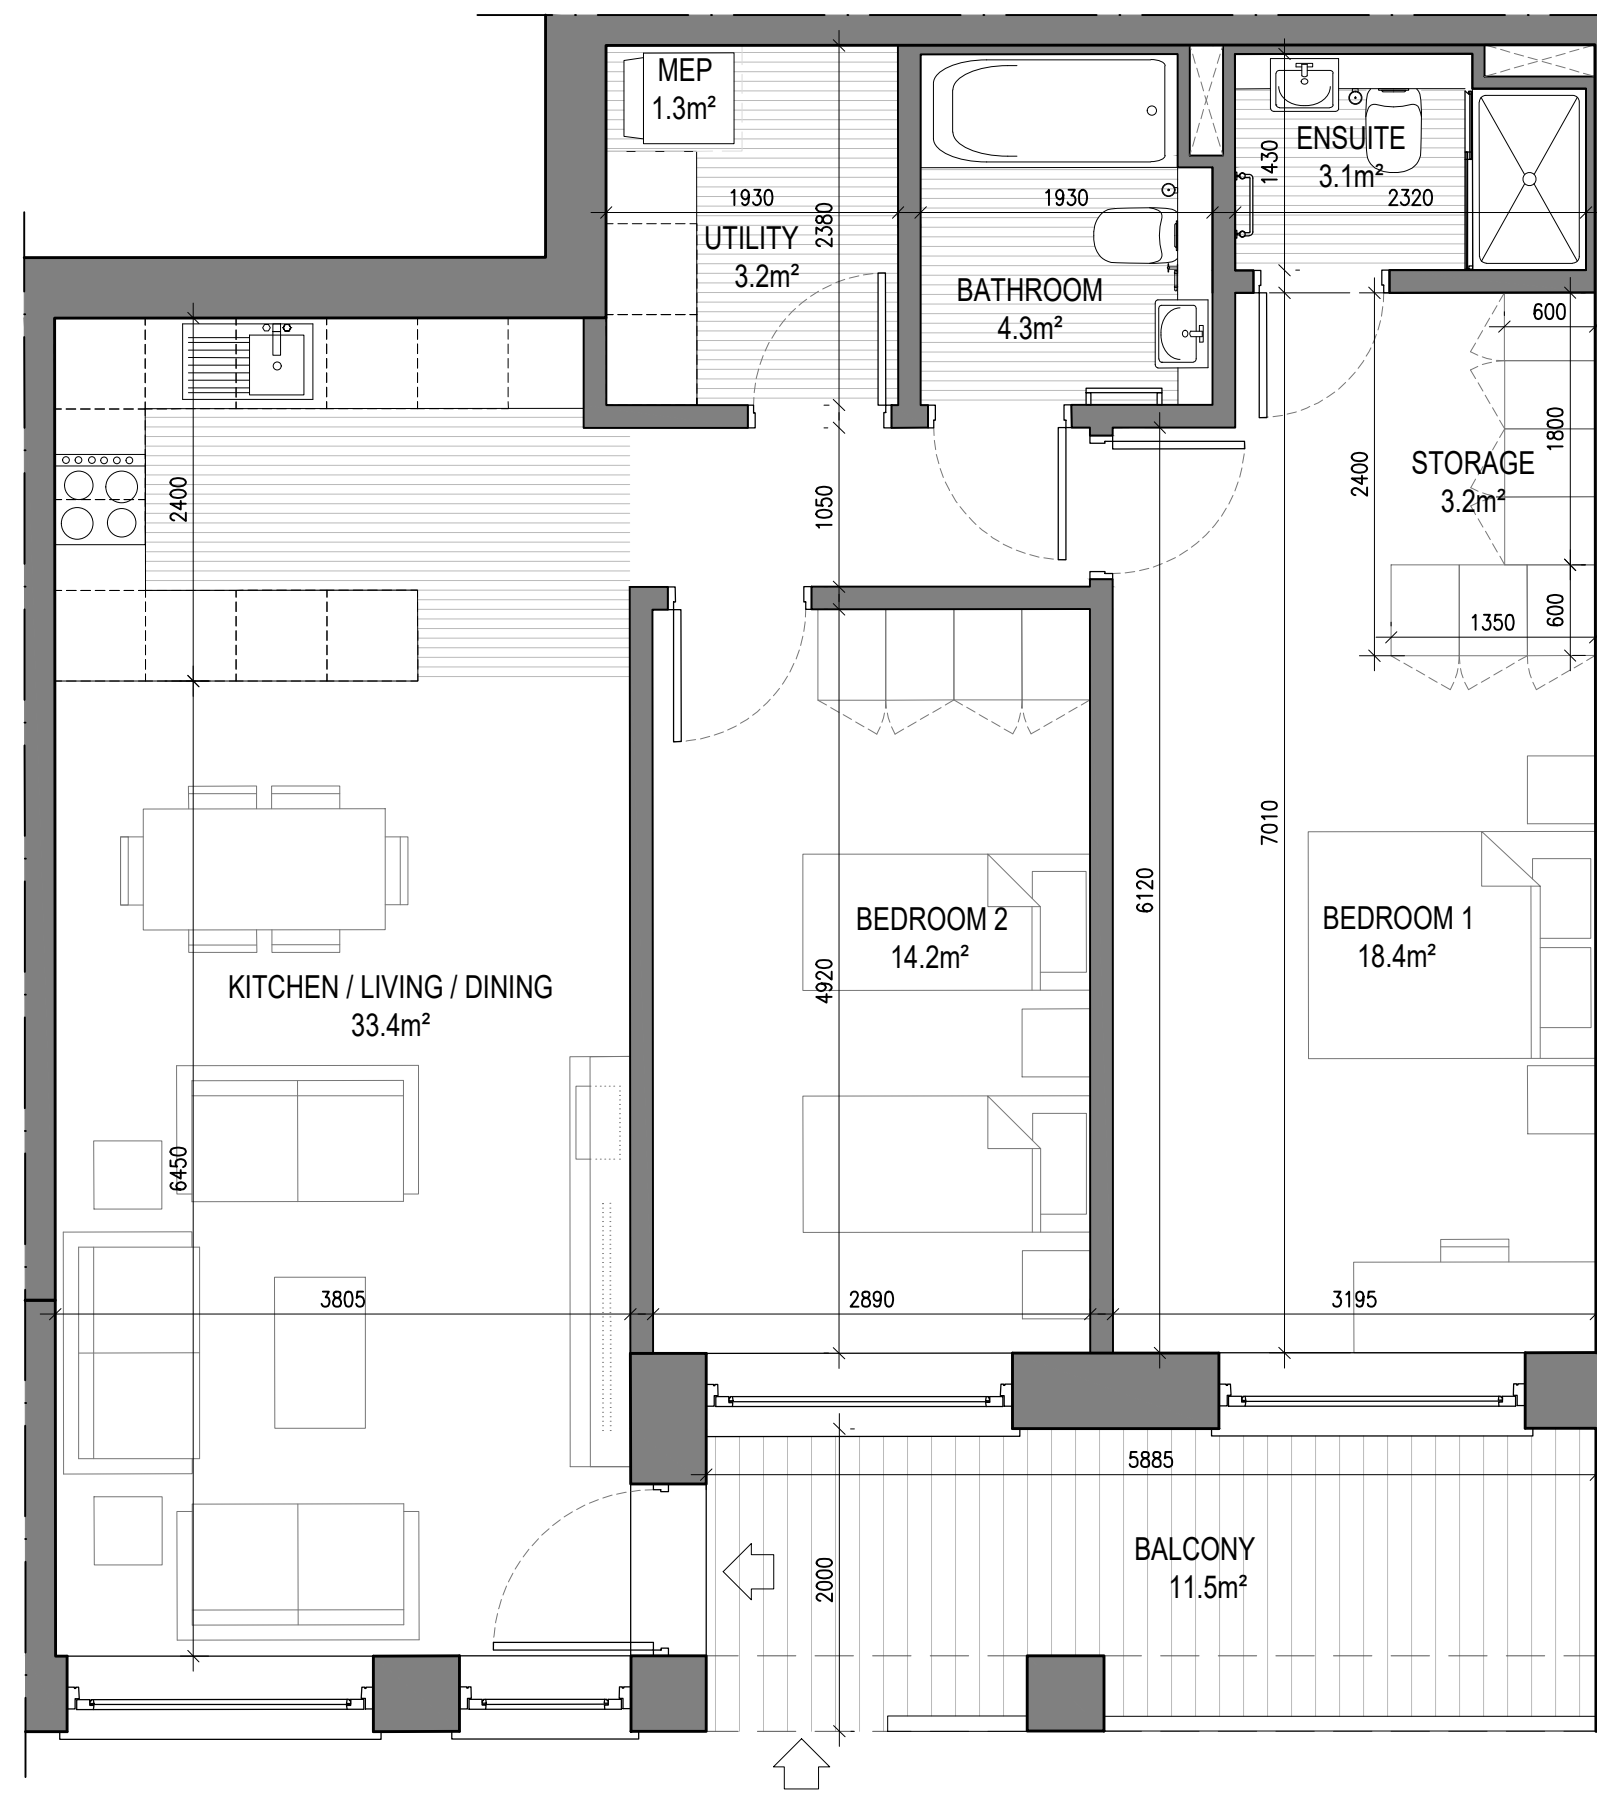


UNIT TYPE B2.5

2 Beds Unit - Floor Area: 89.17m²


SCALE 1:50

NOTE: UNITS 111, 121, 131, 141 & 151 LAYOUT IS MIRRORED EAST TO WEST


	REQUIRED [m²]	PROVIDED [m²]
STORAGE SPACE	6.0	6.4
PRIVATE AMENITY SPACE	7.0	11.5
AGGREGATE BEDROOM AREA	24.4	25.4
AGGREGATE KITCHEN / LIVING / DINING	30.0	36.3

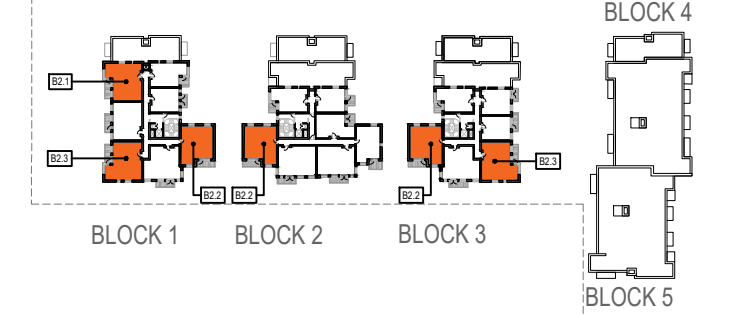


5
P-200
KEYPLAN
LEVEL 5 - 1:2000

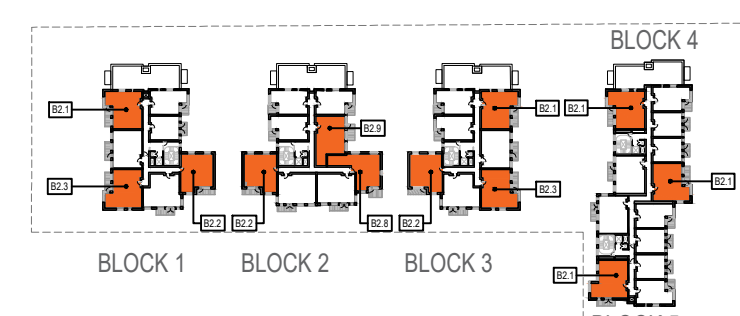


4
P-200
KEYPLAN
LEVEL 4 - 1:2000

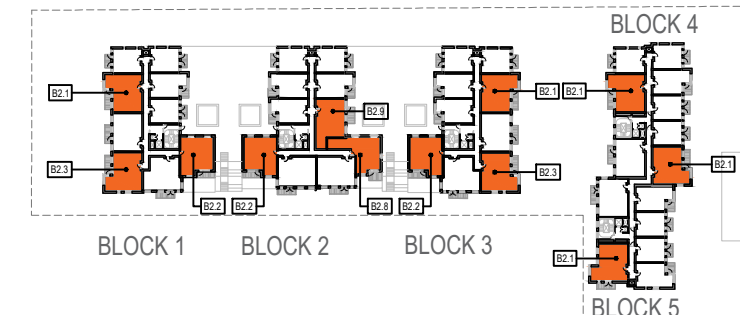

1-3
P-200
KEYPLAN
LEVEL 1 TO 3 - 1:2000

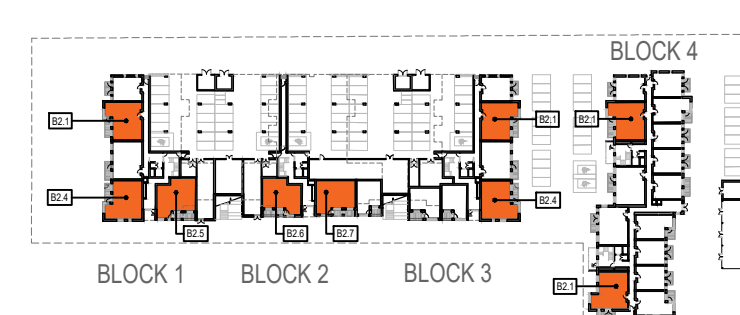

0
P-200
KEYPLAN
LEVEL 0 - 1:2000

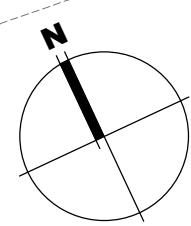

**PERMITTED DEVELOPMENT UNDER
SHD PERMISSION ABP-313043-22**

FOR INFORMATION ONLY

Notes
1. Copyright Reserved
2. Work to figure dimensions only. Do not scale drawing.
3. The contractor is responsible for checking all levels and dimensions on site and shall refer all discrepancies to the Architect.
4. Where appropriate, for details of r.c. structure, or mechanical and electrical details, see Engineers drawings.
5. Proprietary items shall be fixed in strict accordance with manufacturers instructions.
6. Sizes of proprietary items shall be checked with manufacturer.
7. The contractor shall be responsible for the coordination of structure, finishes and services.

Issue Status
Progress
Planning Application
Fire Cert
Disability Cert
Tender
Construction
As Built
Information Only

M:\Project Section - Current\6269 Carlisle Site Terenure\CAD\Planning\02_LRD Planning Files\21102_Permitted Drawings Set\DWG\6269-P-200 - Proposed Unit Types - Internal Layouts.dwg
Standard\6269-P-200 - Proposed Unit Types - Internal Layouts.dwg 03/11/2022 17:35:49

No.	Date	Revision	Initials
01	02/11/22	Issued for information only	BKD

Project
**Carlisle Site, Kimmage
Residential Development**

Drawing Title
Permitted Unit Types - Internal Layouts - Sheet 3 of 4

Drawing No
6269-P-203

Scale
1:50@A1

Rev
01

Drawn
BKD

Date
26/08/21

6-7 HARCOURT TERRACE, DUBLIN 2, IRELAND
T: +353-1-618 2100 F: +353-1-618 7385
www.bkd.ie

bkdarchitects
BURKE-KENNEDY DOYLE