
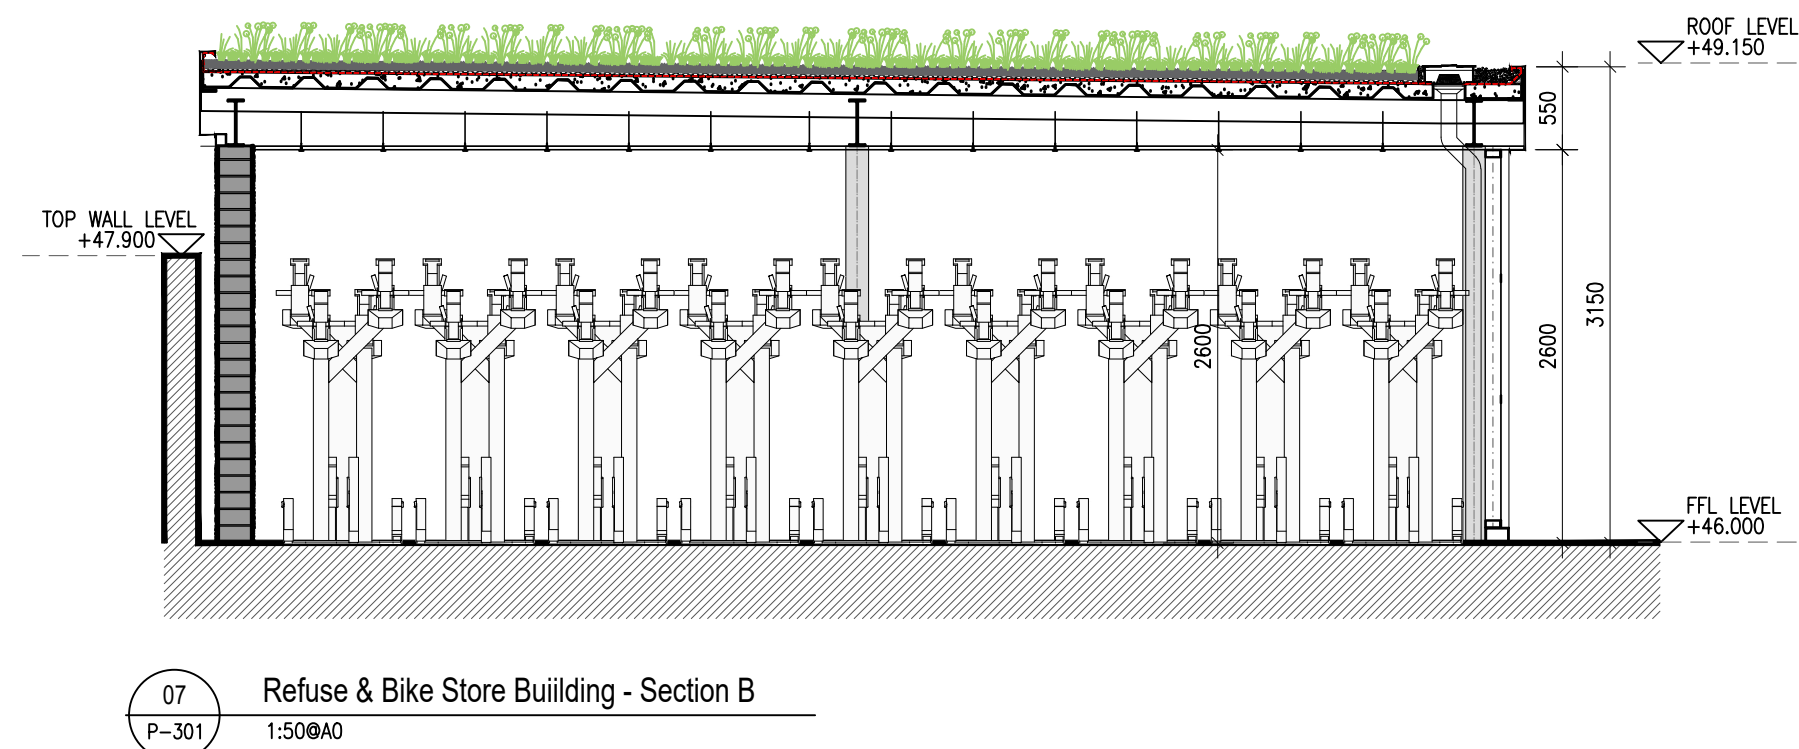
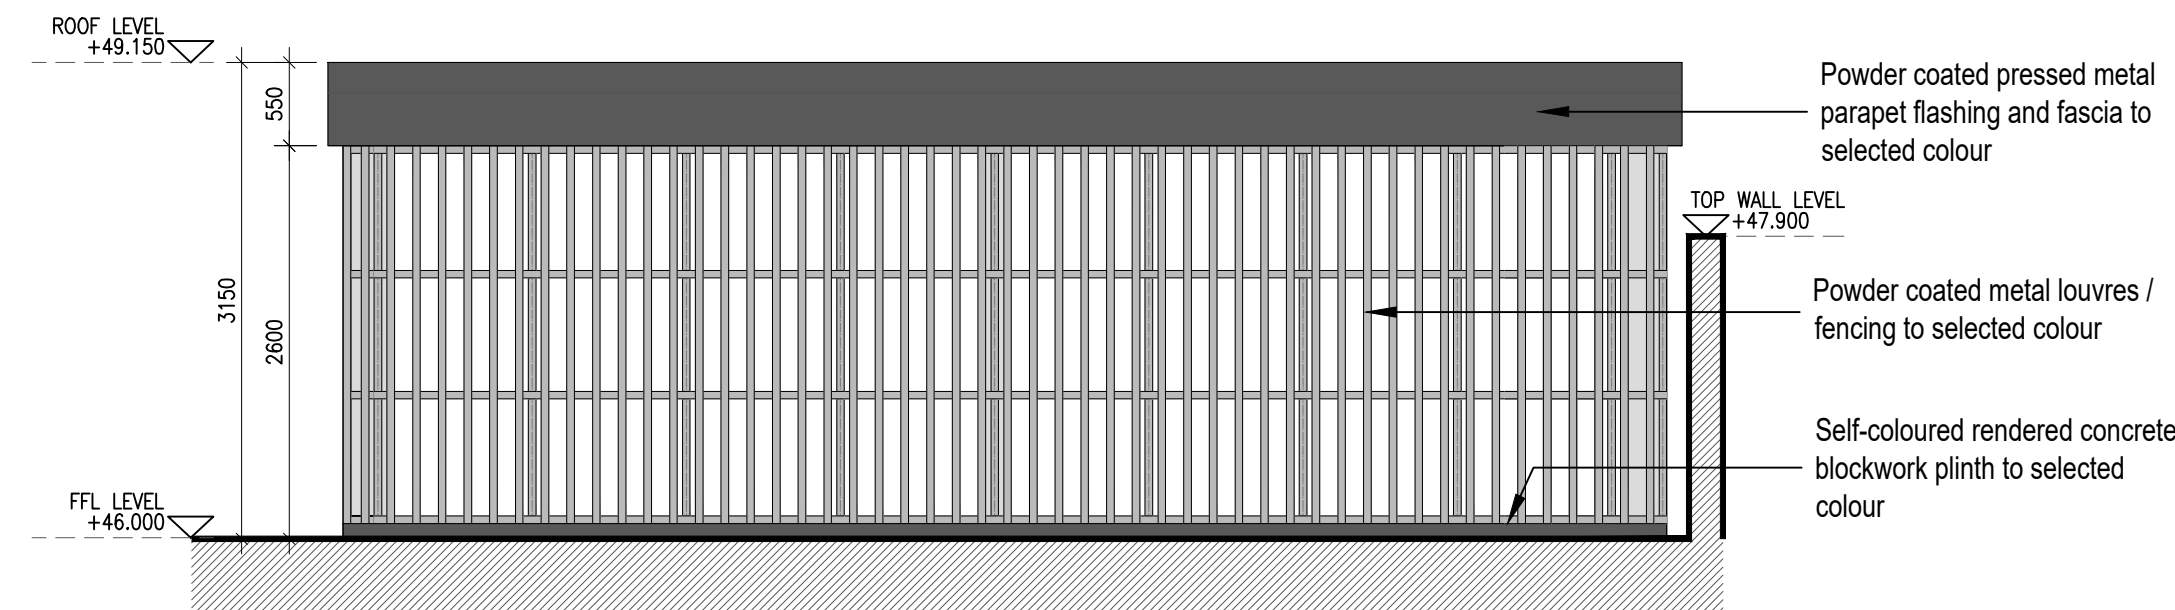
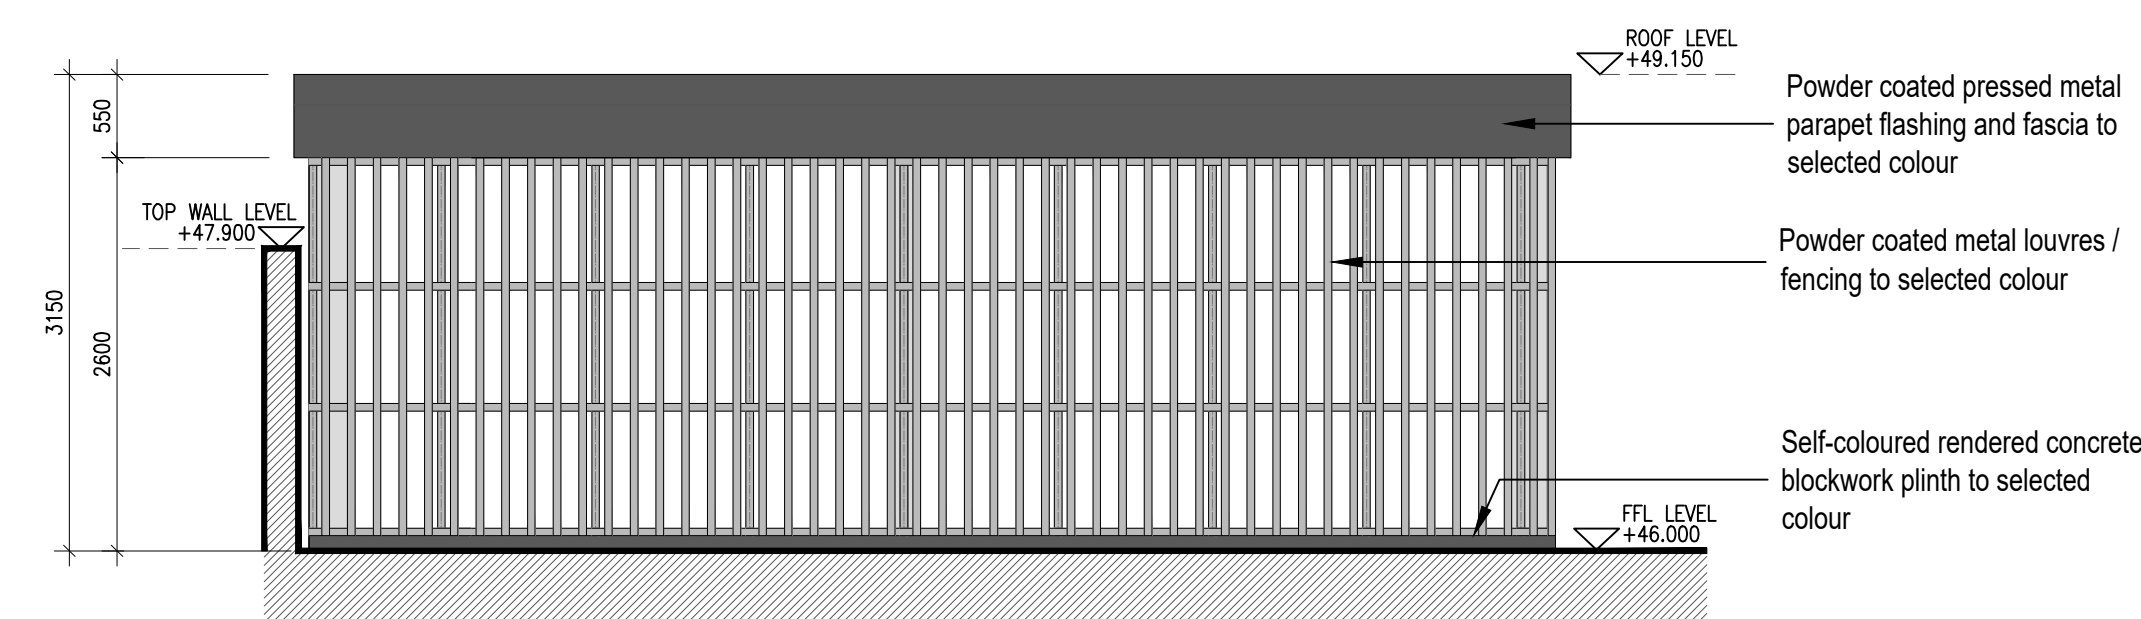
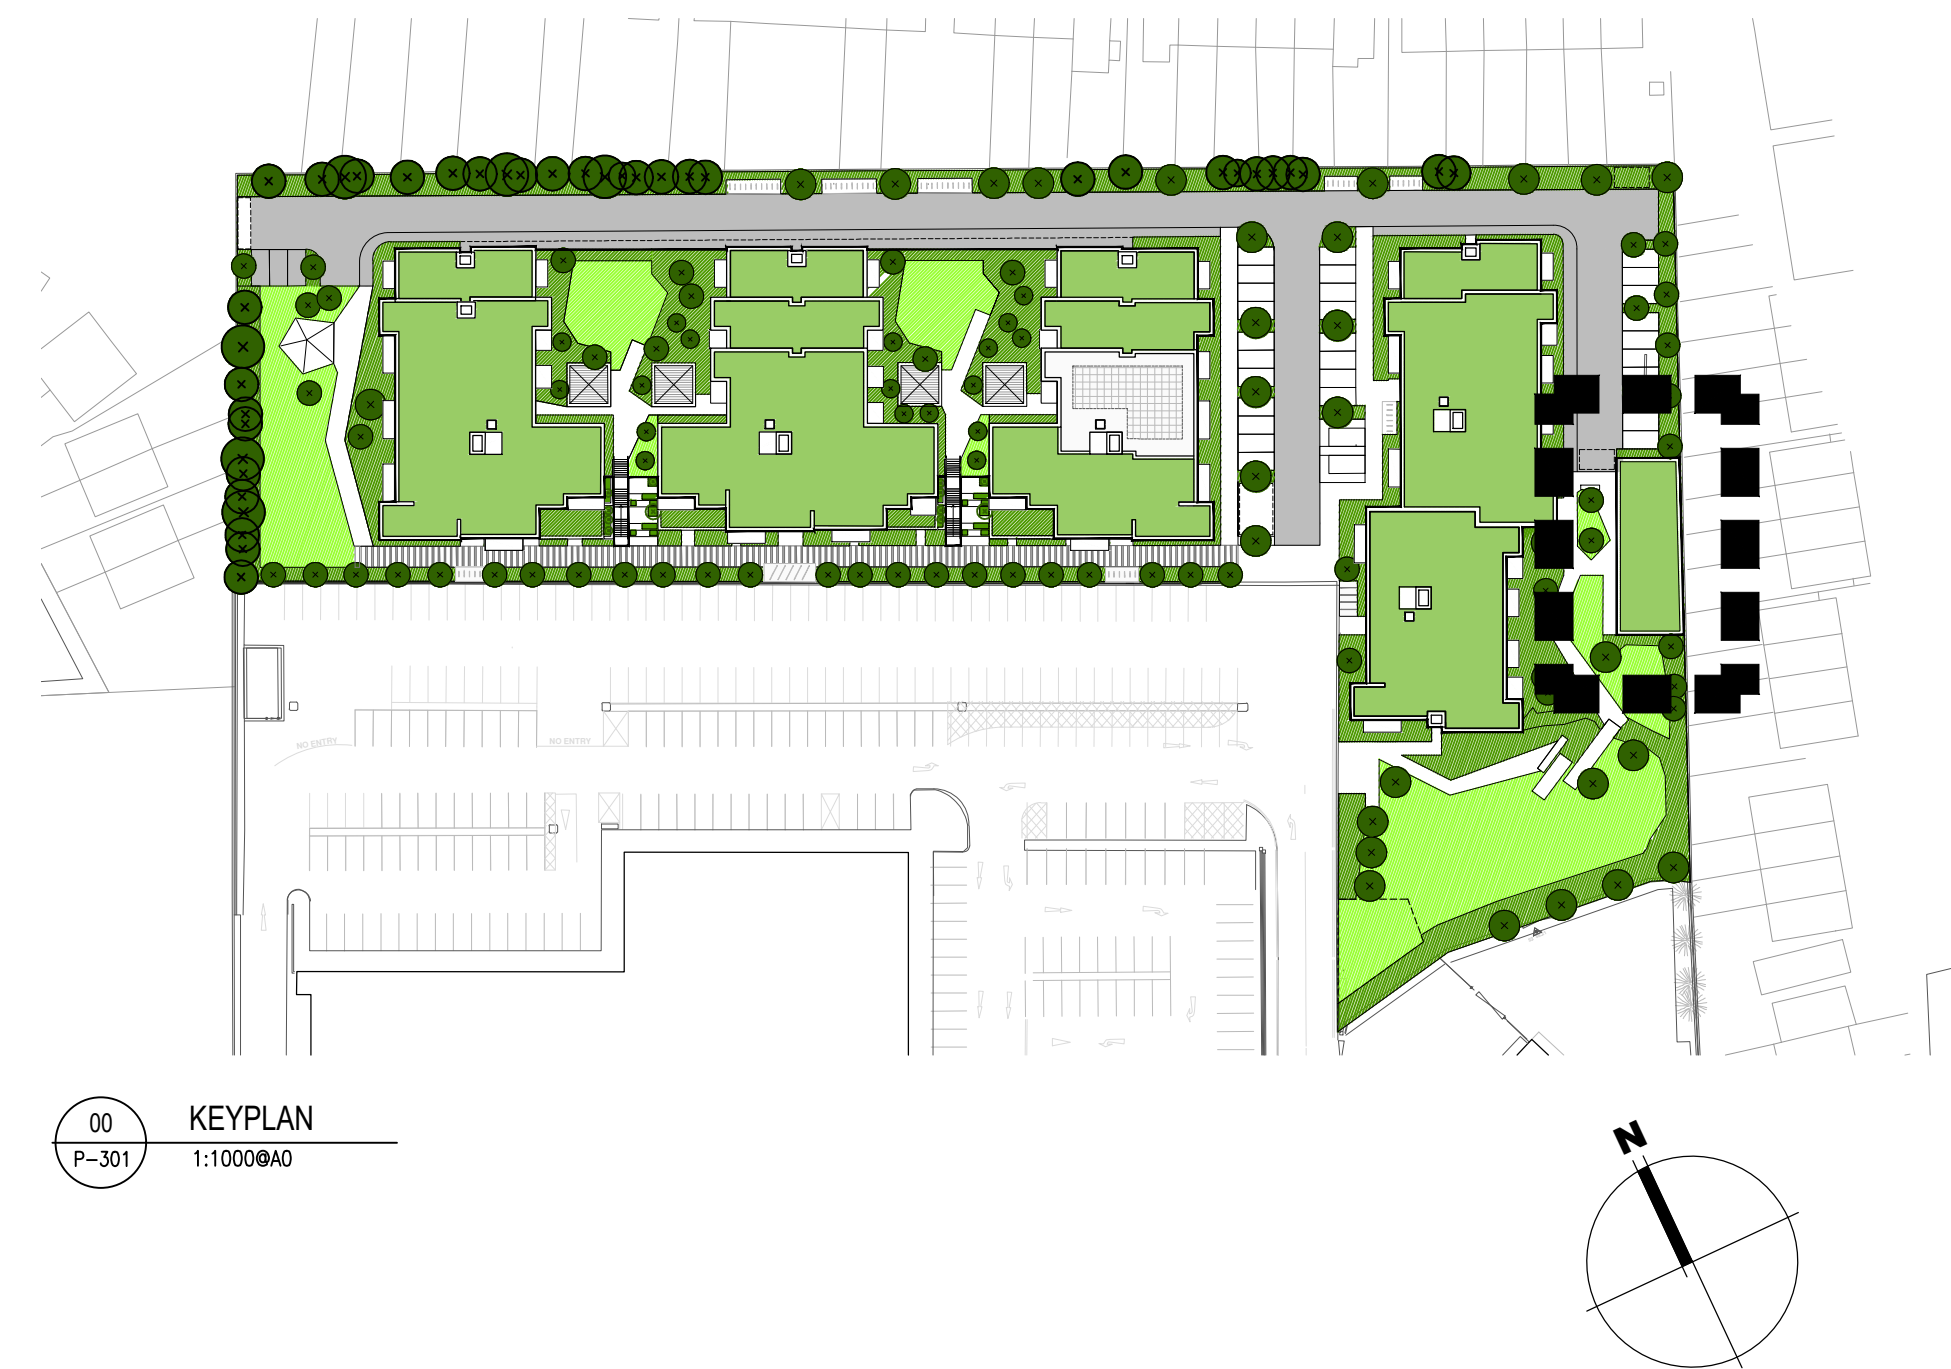
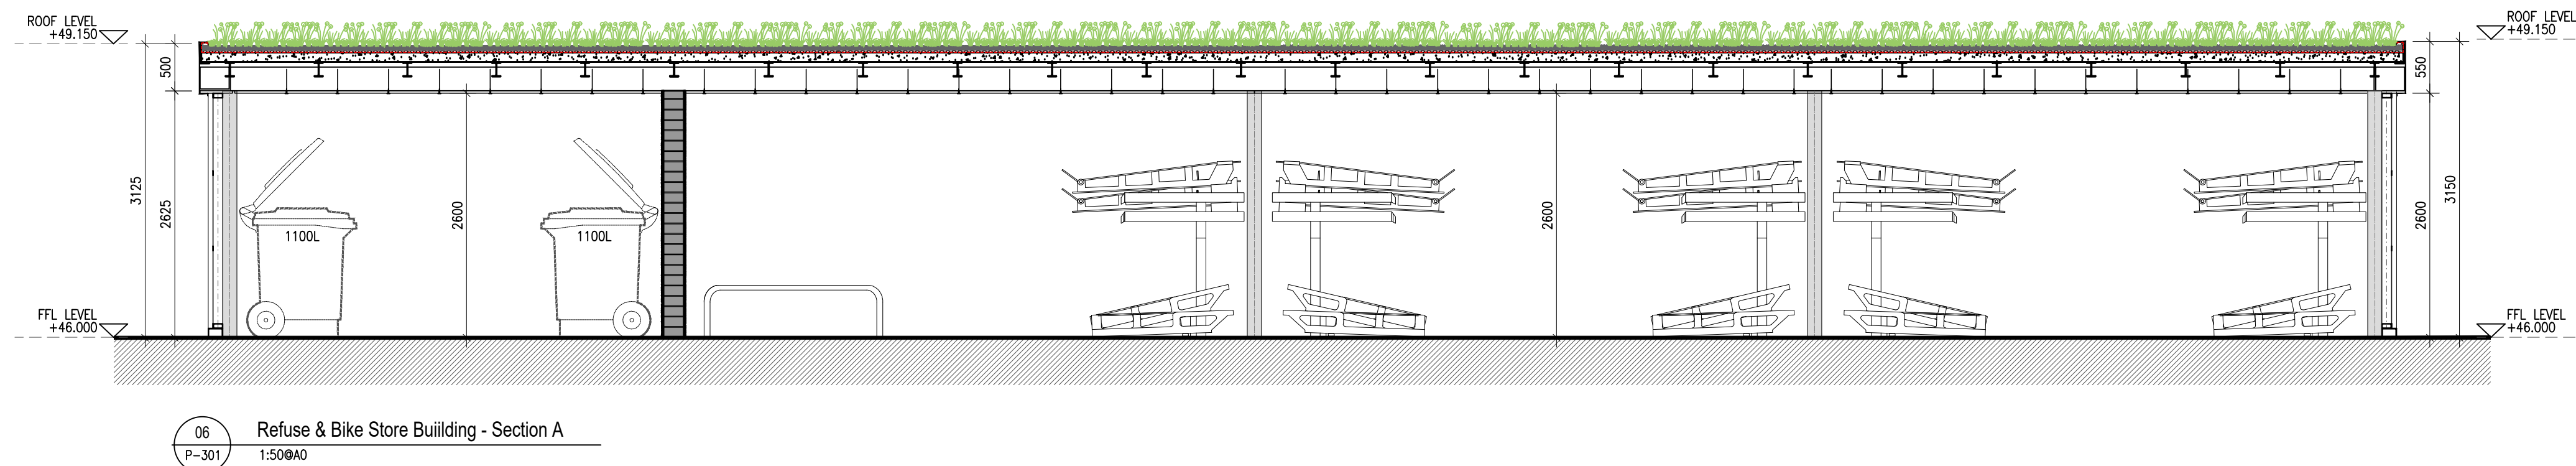
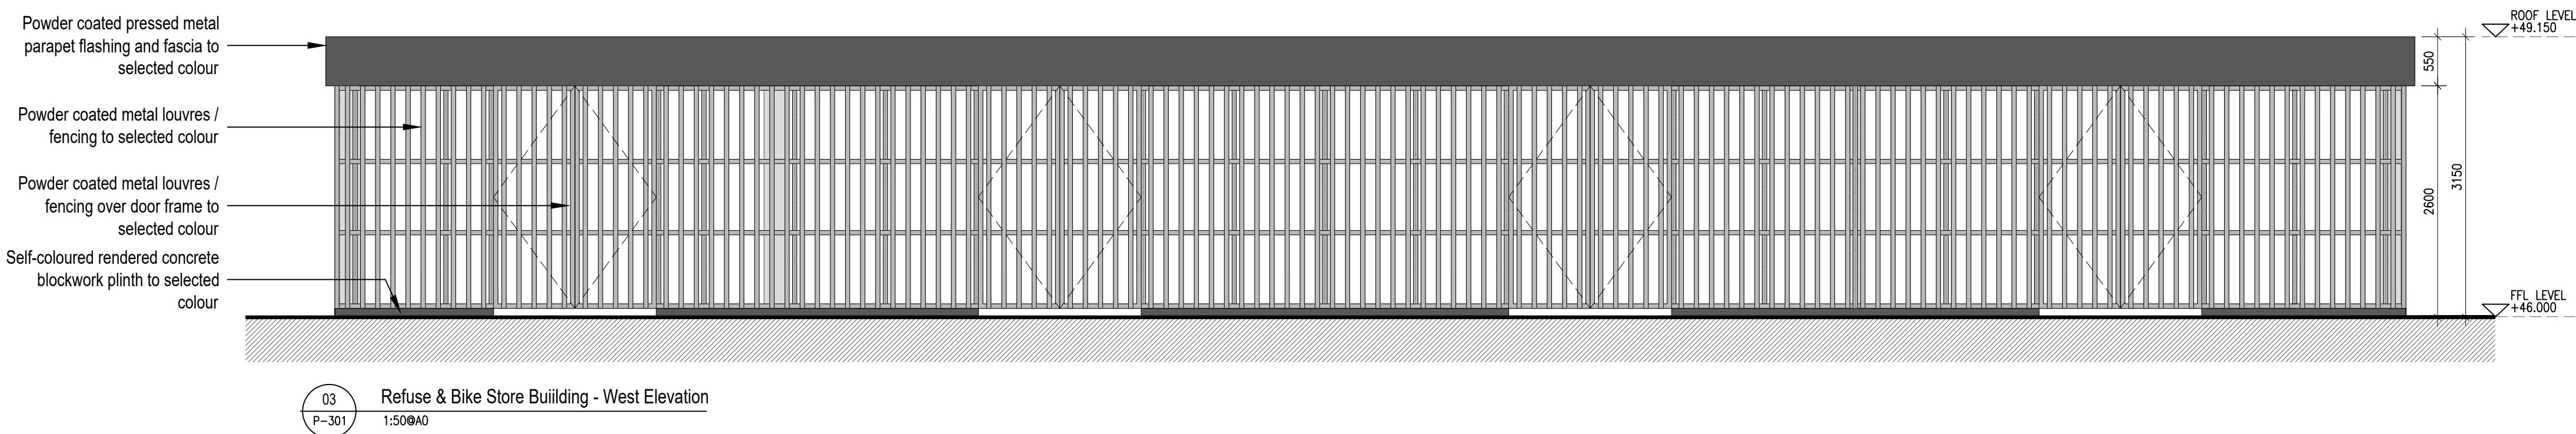
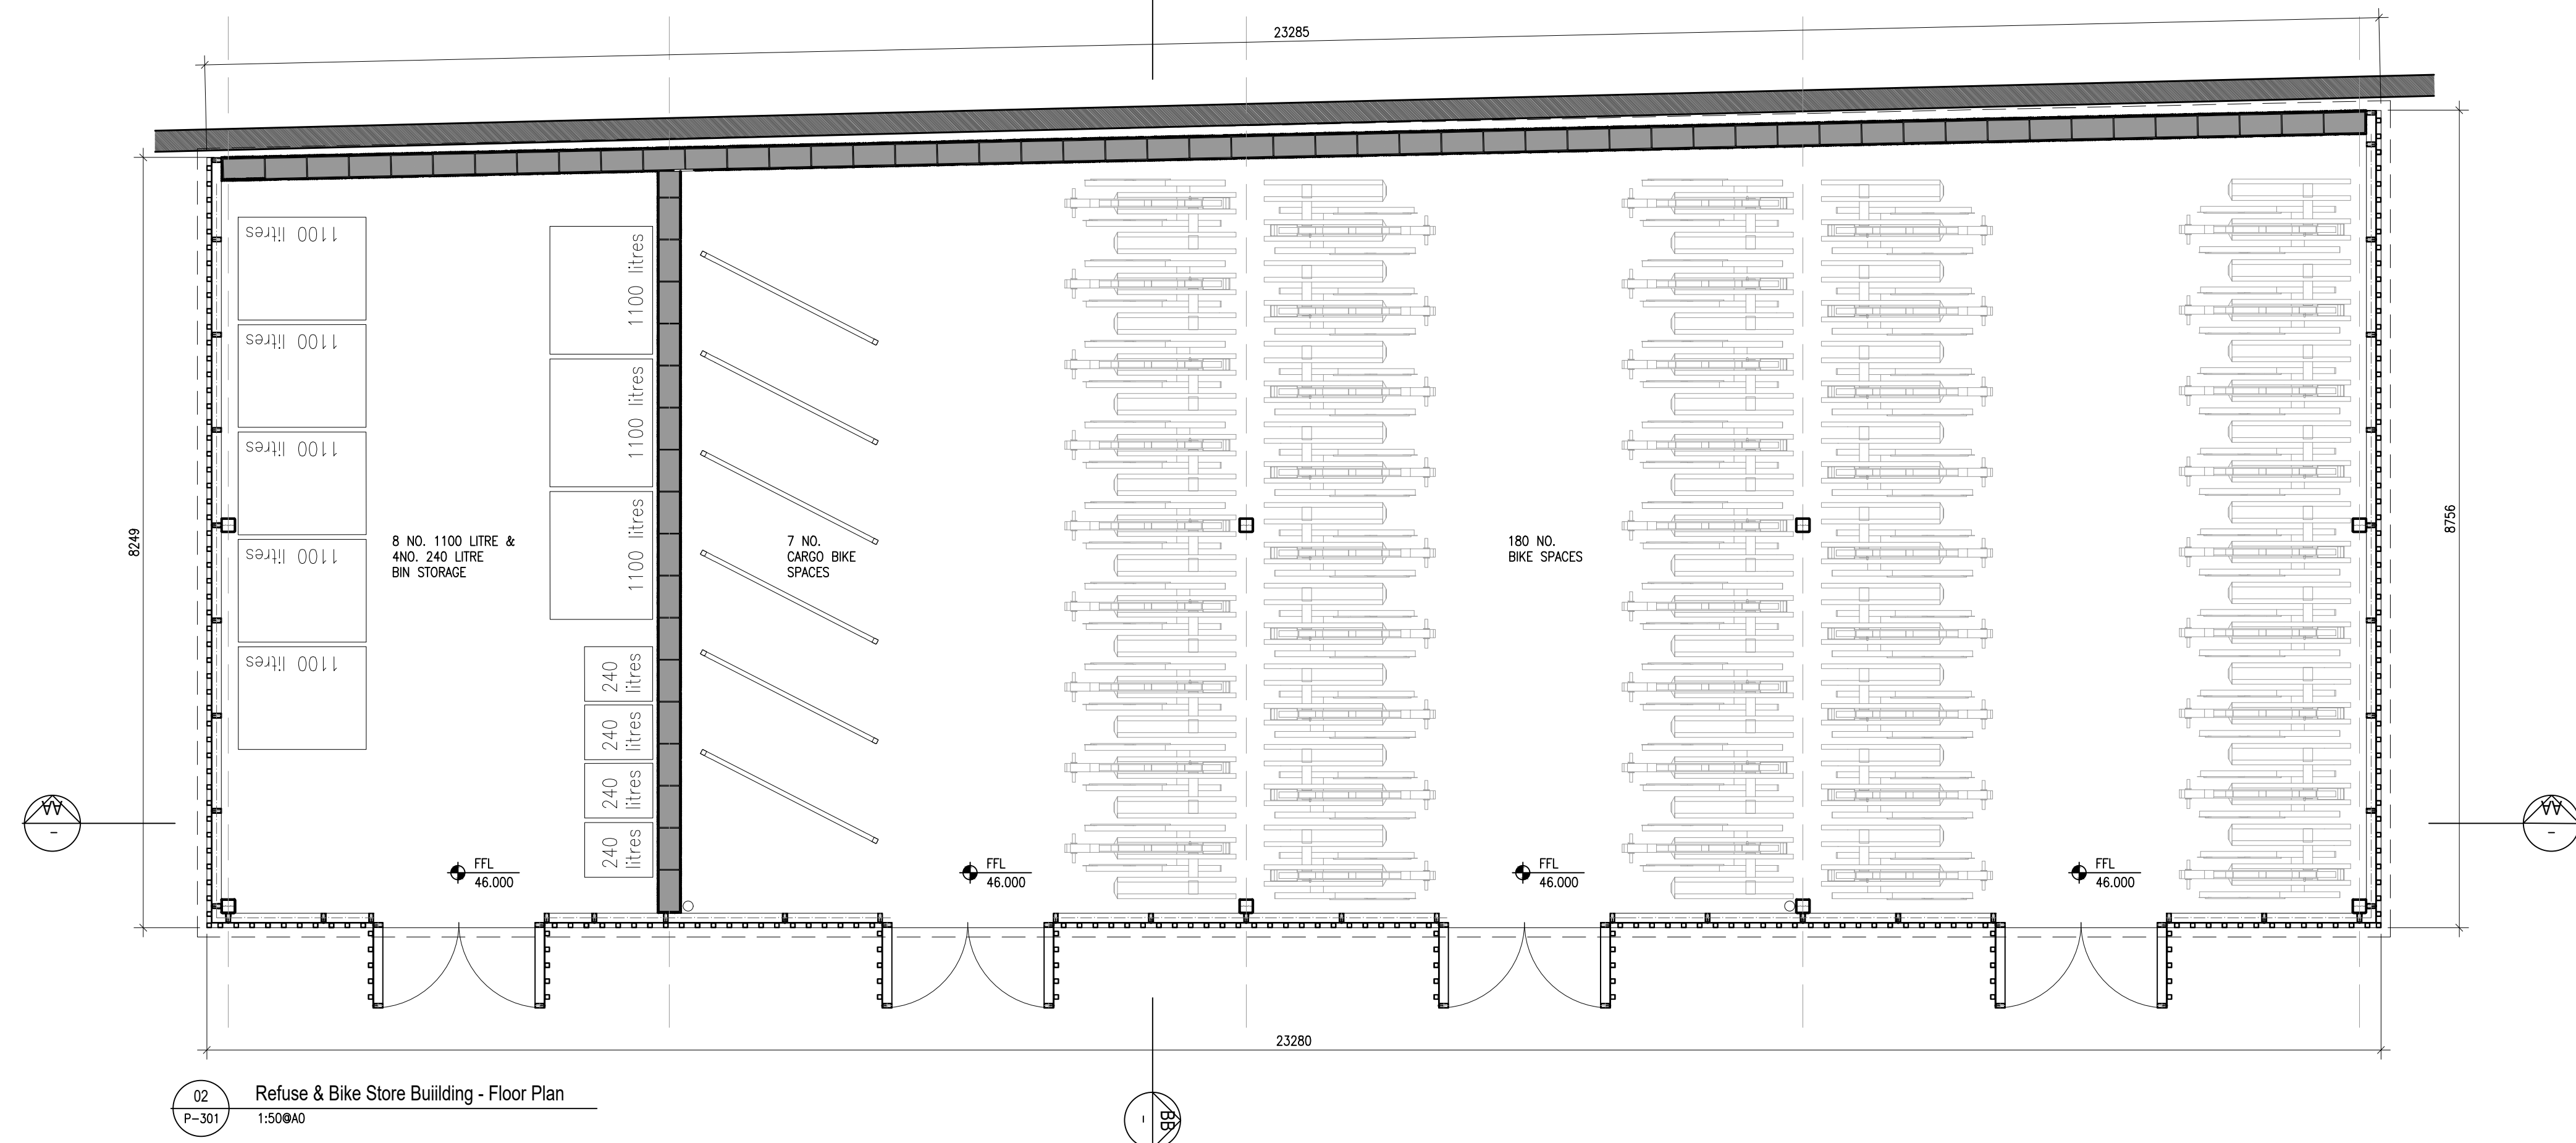


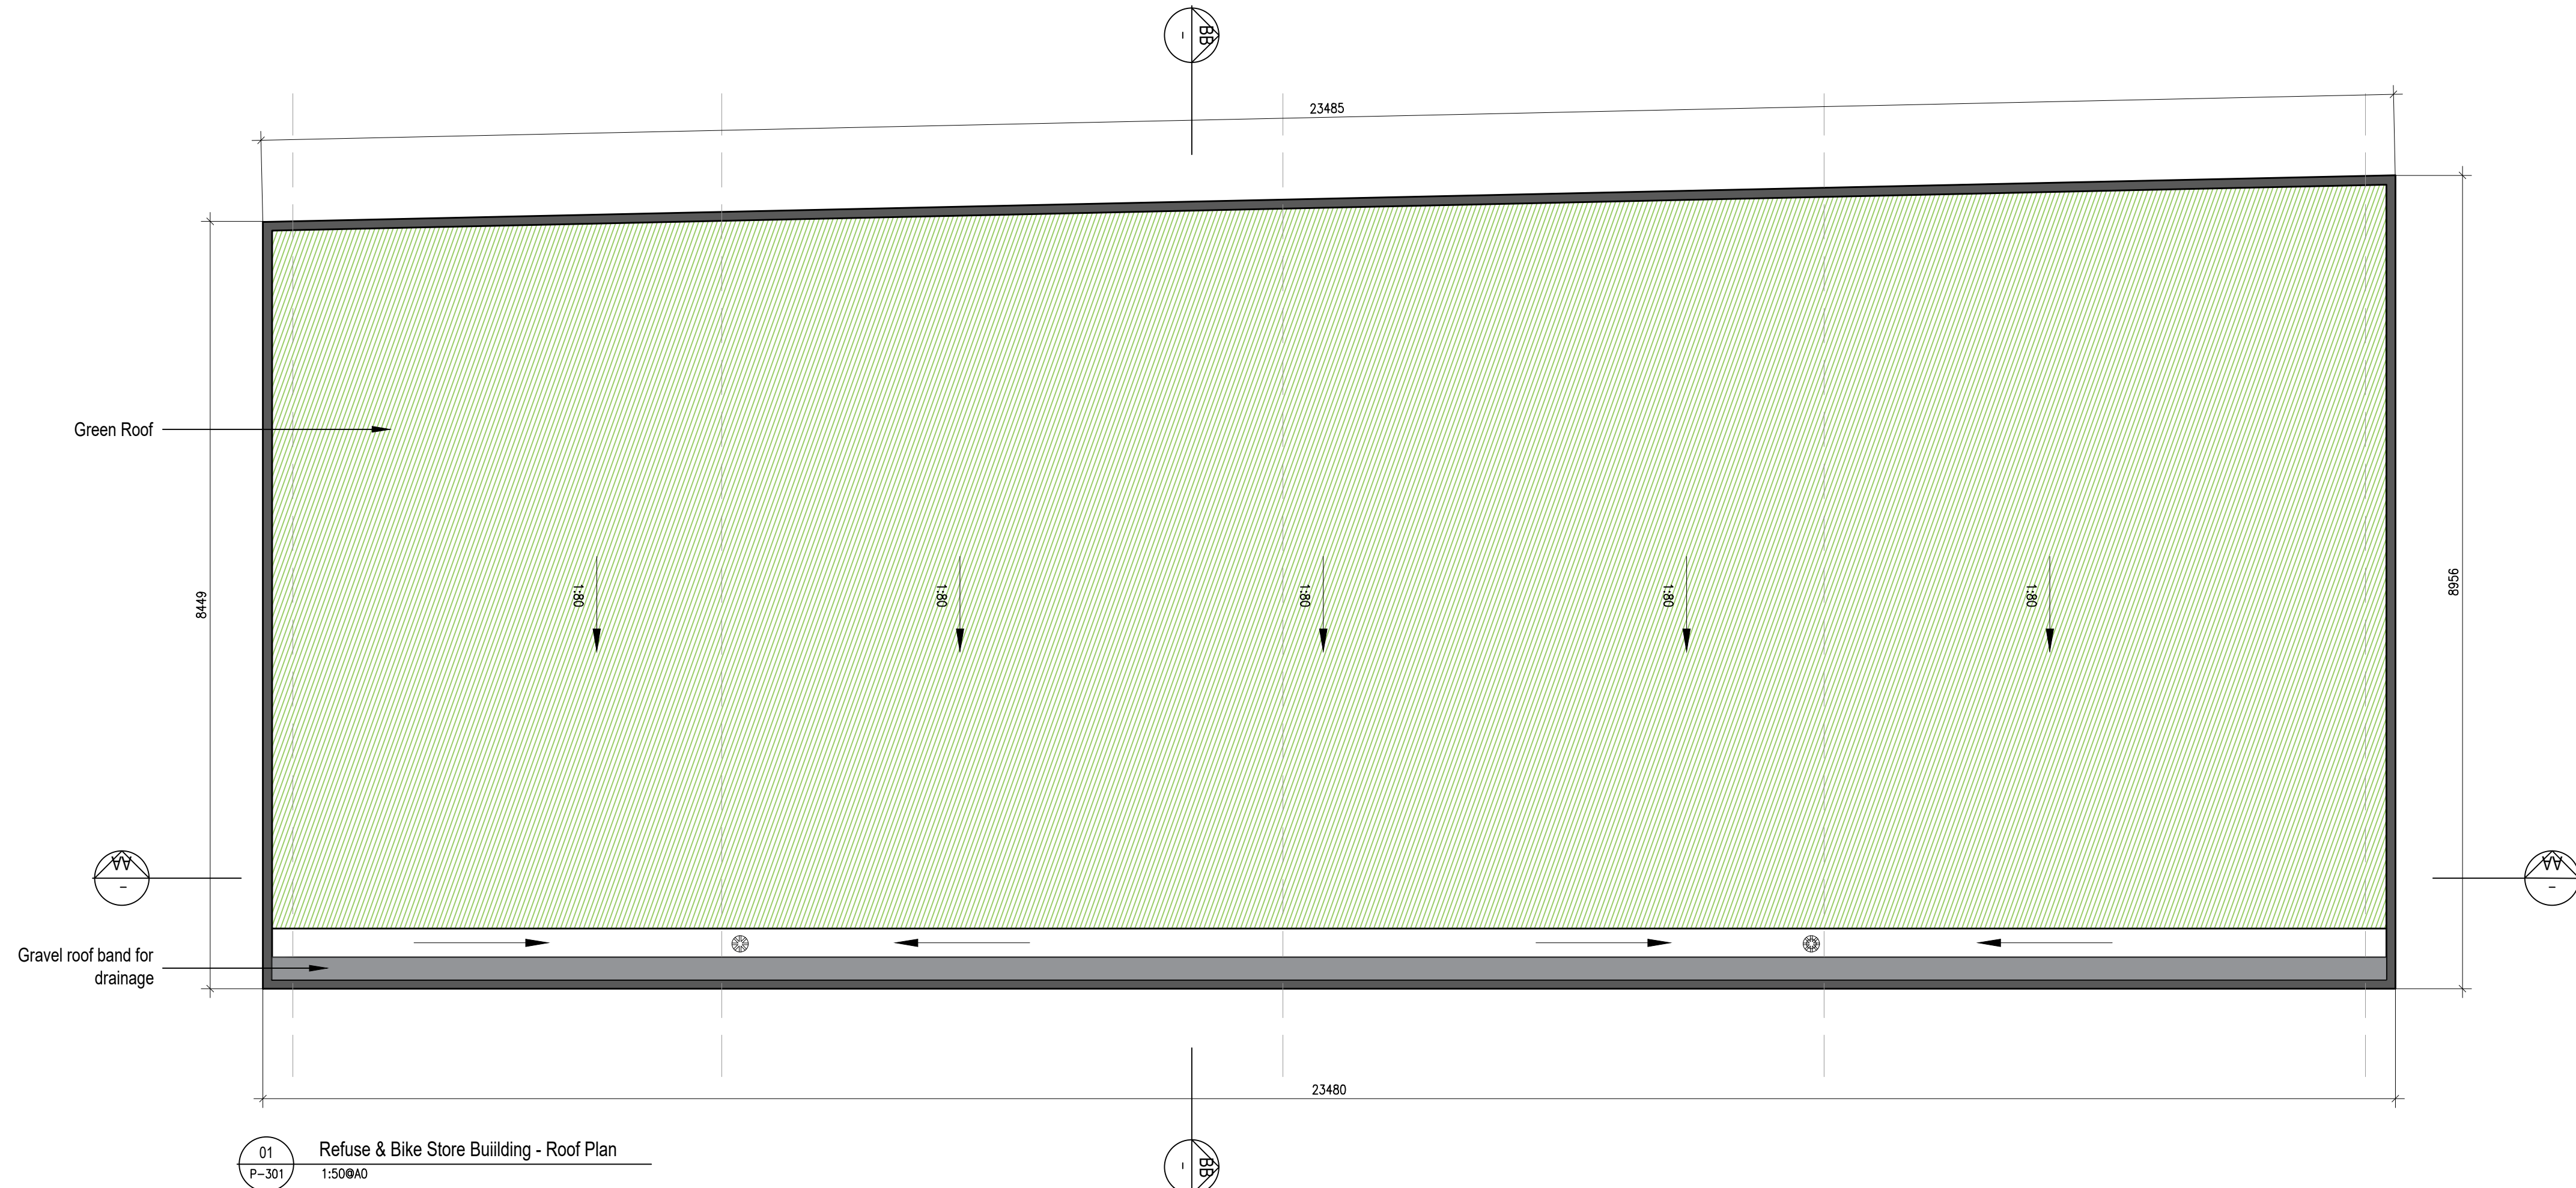

**PERMITTED DEVELOPMENT UNDER
SHD PERMISSION ABP-313043-22**

FOR INFORMATION ONLY

Notes:
1. Copyright Reserved
2. Work to agreed dimensions only. Do not scale drawing.
3. The contractor is responsible for checking all levels and dimensions on site and shall refer all discrepancies to the Architect.
4. Where appropriate, for details of e.g. structure, or mechanical and electrical details, see Engineer's drawings.
5. Proprietary items shall be fixed in strict accordance with manufacturers' instructions.
6. Space of proprietary items shall be checked with manufacturer.
7. The contractor shall be responsible for the coordination of structural, finishes and services.

Issue Status
Progress
Planning Application
Fire Cert
Disability Cert
Type
Construction
As Built
Information Only
Refuse & Bike Store Building - Section A
1:500A0

No. Date Revision
01 02/11/22 Issued for information only

Project
Carlisle Site, Kimmage
Residential Development

Drawing Title
Refuse & Bike Store Building Detail (Permitted)

Drawing No.
6209-P-301

Scale
1:50@A0

Rev
01

Drawn
BKD

Date
26/08/21

17 FIVEQUARTY TERRACE, DUBLIN 8, IRELAND
T: +353 1 608 8800 F: +353 1 608 8801
www.bkd.ie

bkdarchitects
BARRY-KENNEDY-DOYLE